


PROPOSED BATHROOM AND CONCESSION BUILDINGS

FOR: Ivanna Eudora Kean H.S. TRACK & FIELD FACILITY

OWNER: U.S. VIRGIN ISLANDS DEPARTMENT OF EDUCATION


LOCATION: No. 1&2 Estate Nazareth, No.1 Red Hook Quarter

ST. THOMAS, U.S. VIRGIN ISLANDS

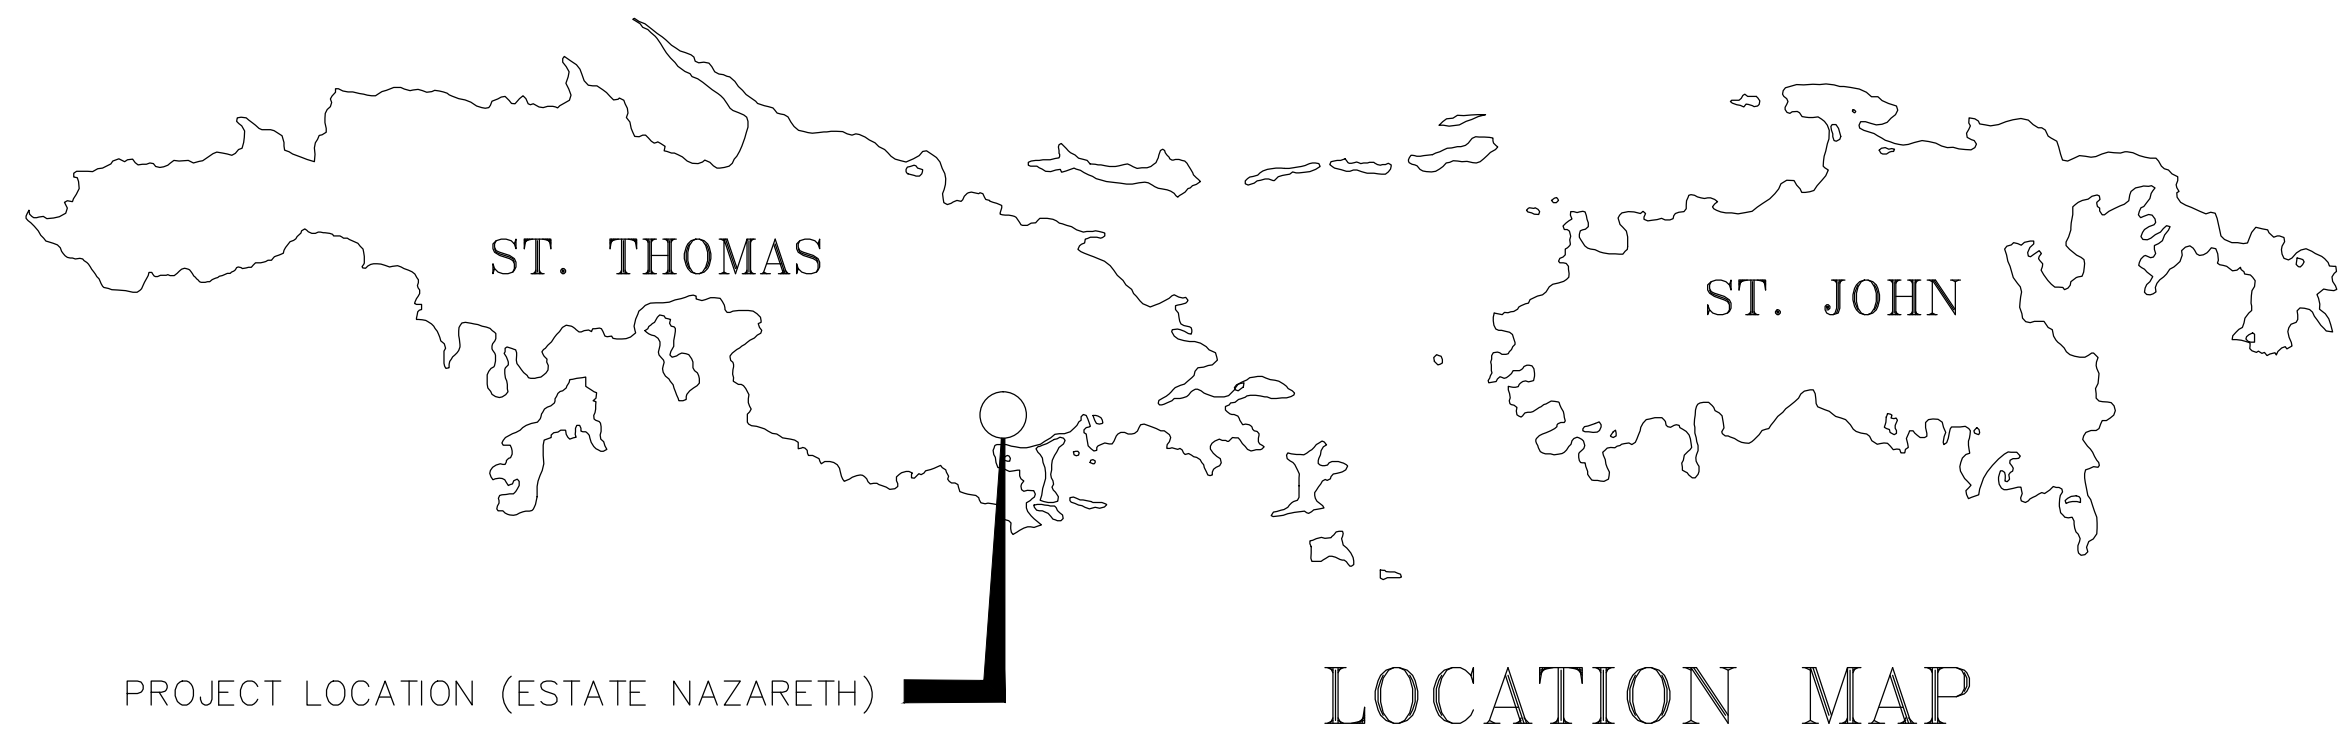

LEGEND

- CVR
- GN
- C-1
- C-2
- A-1
- AE-2
- A-3
- A-4
- A-5
- A-6
- A-7
- A-8
- P-1
- P-2
- E 0.0
- E 1.1
- E 2.0
- E 3.0
- E 4.0
- S-1
- S-2
- S-3
- S-4
- S-5
- COVER SHEET
- GENERAL CONSTRUCTION NOTES
- SITE PLAN LAYOUT
- SITE REINFORCED CONCRETE LAYOUT
- FOUNDATION AND CONSTRUCTION FLOOR PLAN
- ROOF FRAMING AND ELELCTRICAL FLOOR PLAN
- CONCESSION FLOOR PLAN - BLOW UP
- MALE AND FEMALE BATHROOM FLOOR PLAN - BLOW UP
- BUILDING ELEVATIONS & ELEVATION BLDG. SECTIONS
- INTERIOR ELEVATIONS - BLOW UP
- ELEVATION BUILDING SECTIONS - BLOW UP
- ELECTRICAL PANEL ROOMS CONSTRUCTION PLAN
- PLUMBING FLOOR PLANS AND DETAILS
- PLUMBING RISER DIAGRAMS AND DETAILS
- ELELCTRICAL SYMBOL, ABBREVIATIONS AND NOTES
- ELECTRICAL SITE LIGHTING PLAN
- ELECTRICAL SCHEDULES
- RISER AND WIRING DIAGRAM AND DETAILS
- MANUFACTURER'S EQUIPMENT & DETAILS
- FOUNDATION PLAN - BLOW UP
- STRUCTURAL DETAILS
- ROOF AND SITE DETAILS
- RAMP STRUCTURAL DETAILS
- FOUNDATION AND WALKWAY LAYOUT PLAN

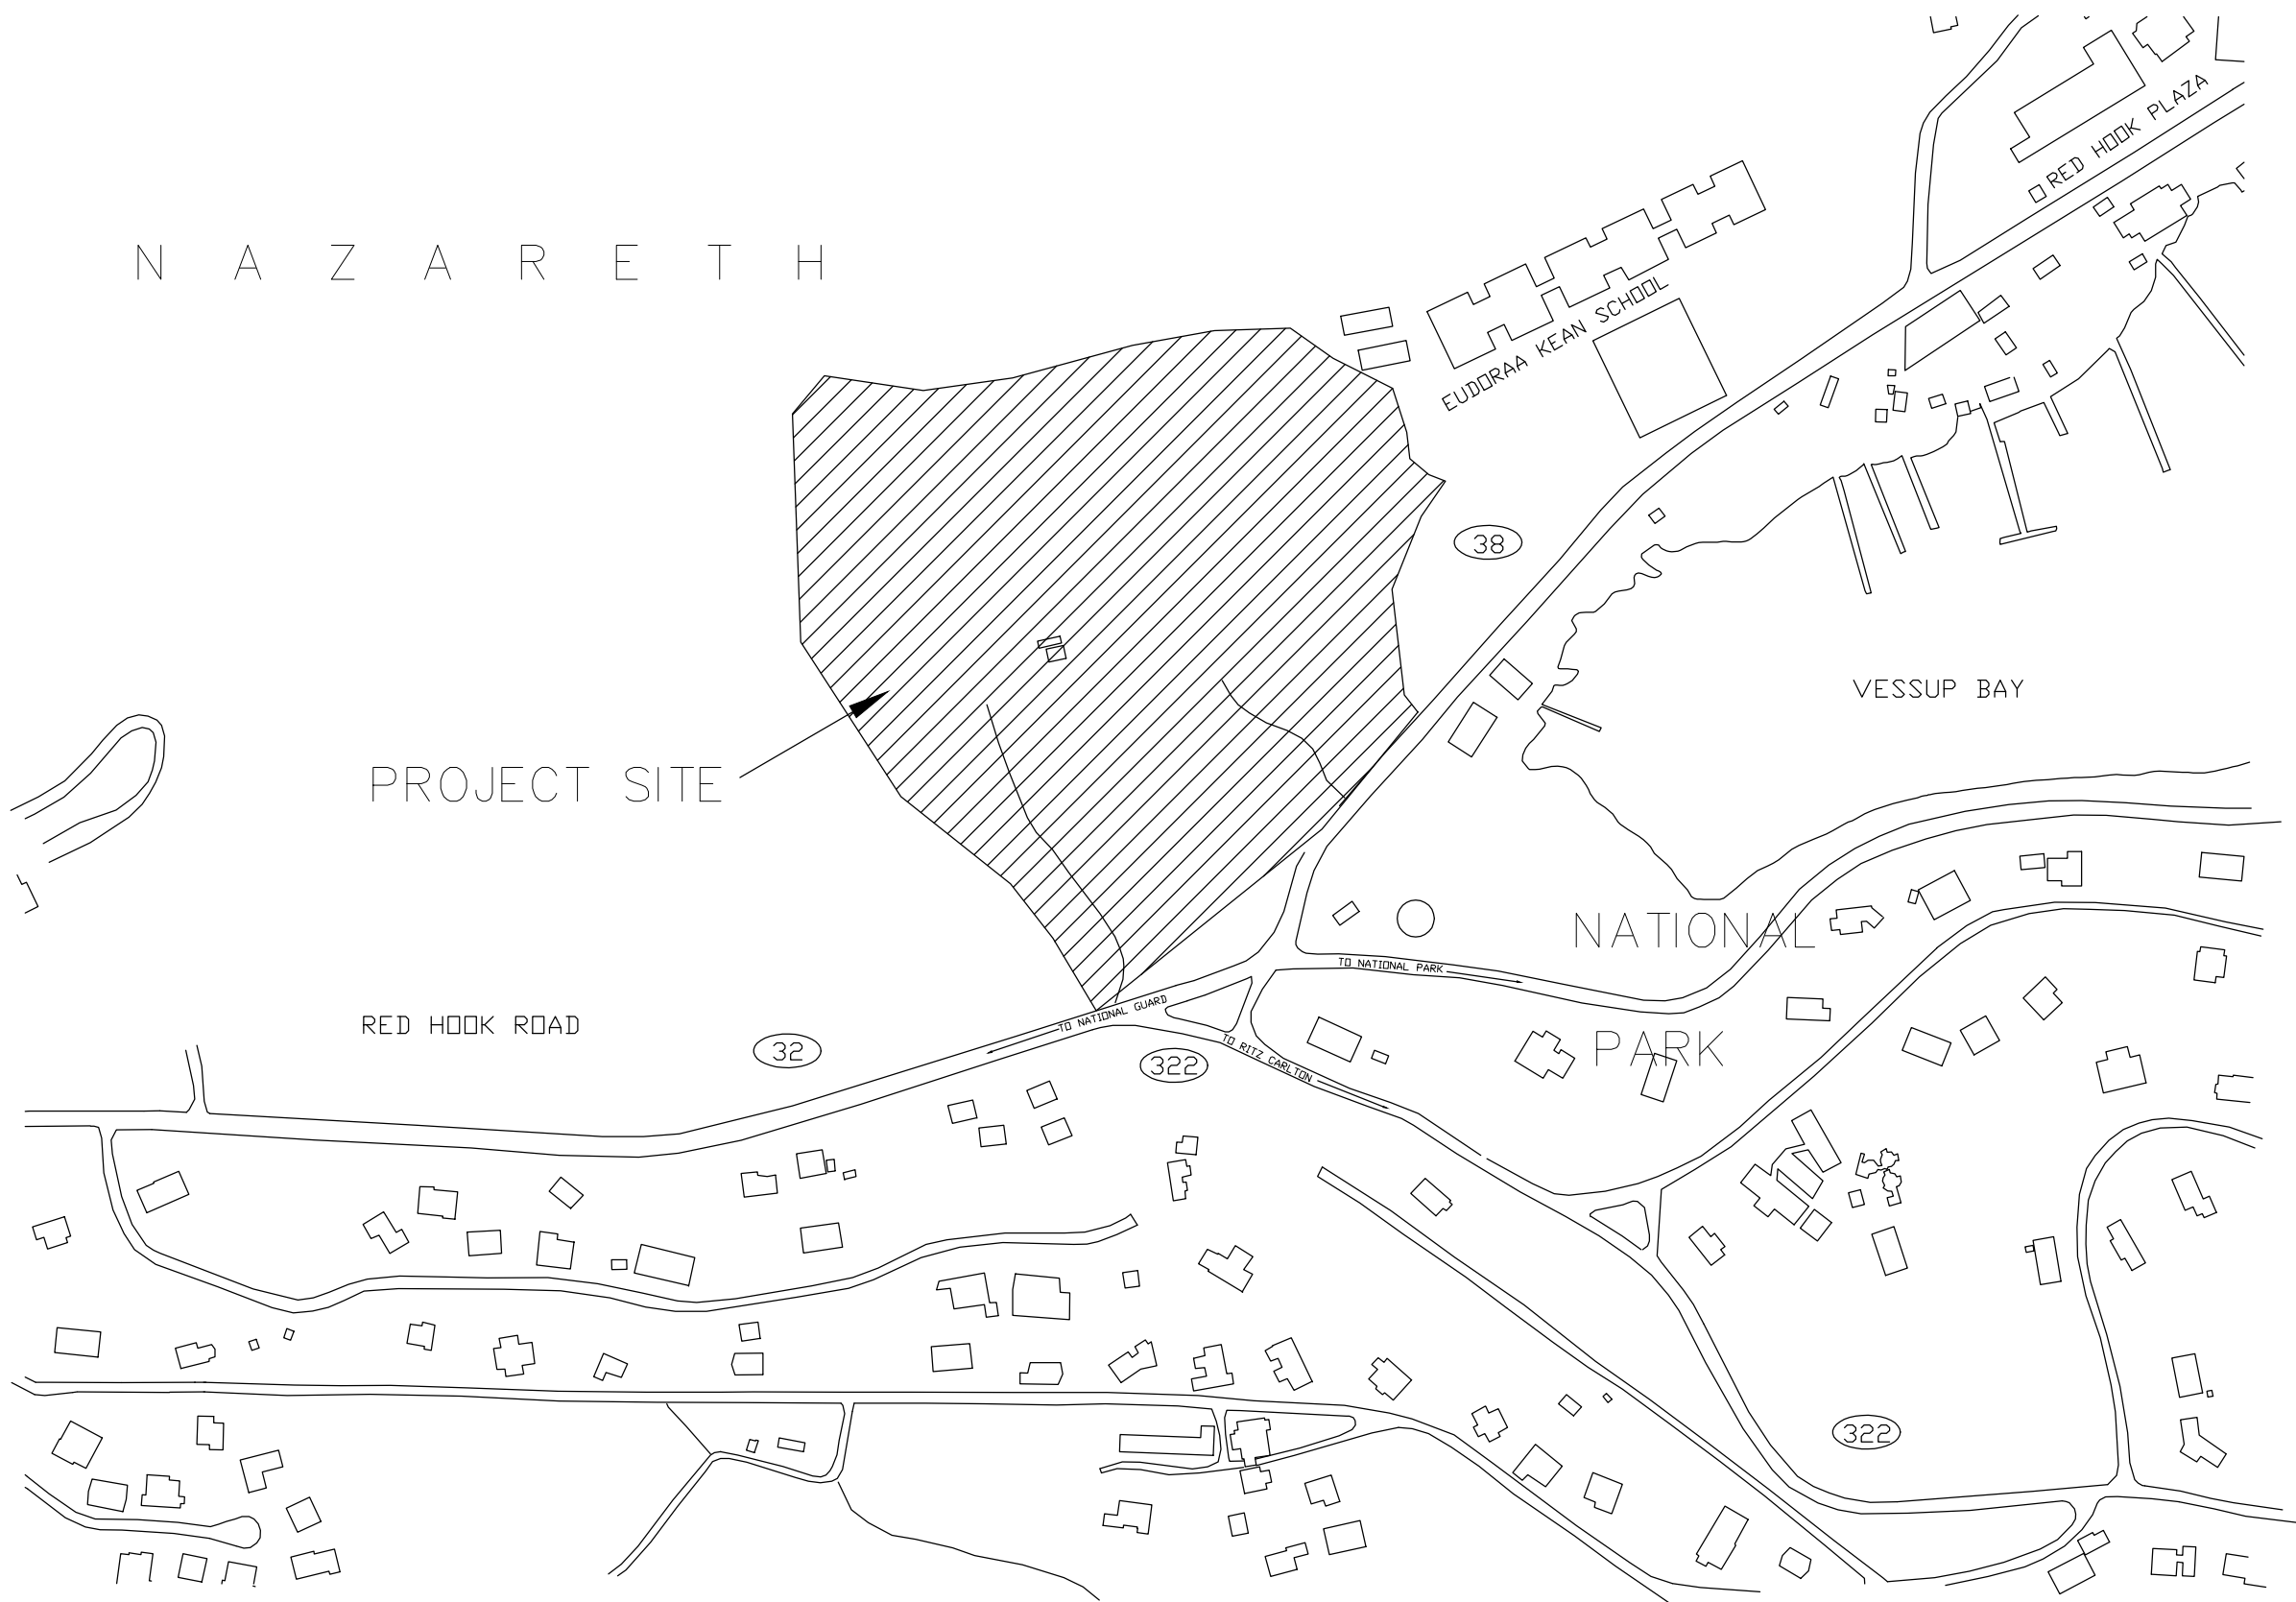

CZM PERMIT No. CZT-45-06L

ORIGINAL BUILDING PERMIT NUMBER: 60-I00-06CZM PERMIT No. CZT-45-06L

Caribbean  
Professional  
Consultants  
P.O. BOX 30647  
212 Bournfield  
St. Thomas, U.S.V.I. 00802  
Tel.: 340-690-7909  
Email: dcarver99@yahoo.com

| REVISIONS |      |         |  |  |
|-----------|------|---------|--|--|
| NO.       | DATE | REMARKS |  |  |
|           |      |         |  |  |
|           |      |         |  |  |
|           |      |         |  |  |
|           |      |         |  |  |
|           |      |         |  |  |

| COVER SHEET / SITE LOCATION PLAN | PROPOSED BATHROOM AND CONCESSION BUILDINGS<br>FOR: IEKHS TRACK & FIELD ATHLETIC FACILITY<br>OWNER: VIRGIN ISLANDS DEPARTMENT OF EDUCATION<br>No. 172 ESTATE NAZARETH, NO.1 RED HOOK QUARTER, STT USVI |
|----------------------------------|-------------------------------------------------------------------------------------------------------------------------------------------------------------------------------------------------------|
|                                  |                                                                                                                                                                                                       |

|               |              |
|---------------|--------------|
| DRAWN BY:     | EJB          |
| CHECKED BY:   | EJB          |
| APPROVED BY:  | EJB          |
| CONTRACT NO.: | CONTRACT.NO. |
| PROJECT NO.:  | PROJ.NO.     |
| DATE:         |              |



|             |             |
|-------------|-------------|
| SHEET NO.:  | CVR         |
| SHEET NO. # | OF # SHEETS |