




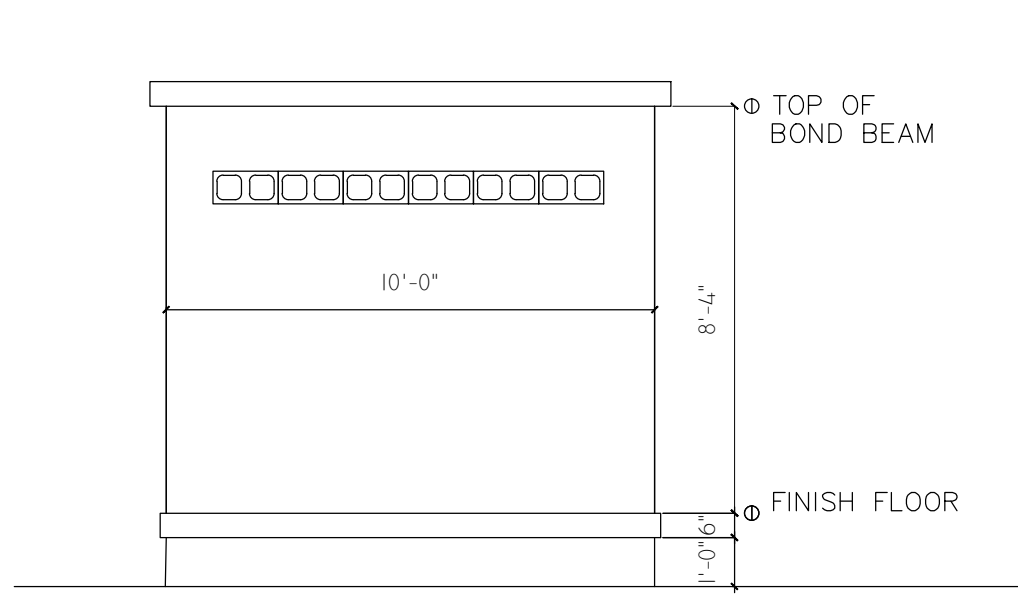


REAR ELEVATION
Scale: 1/4" = 1'-0"

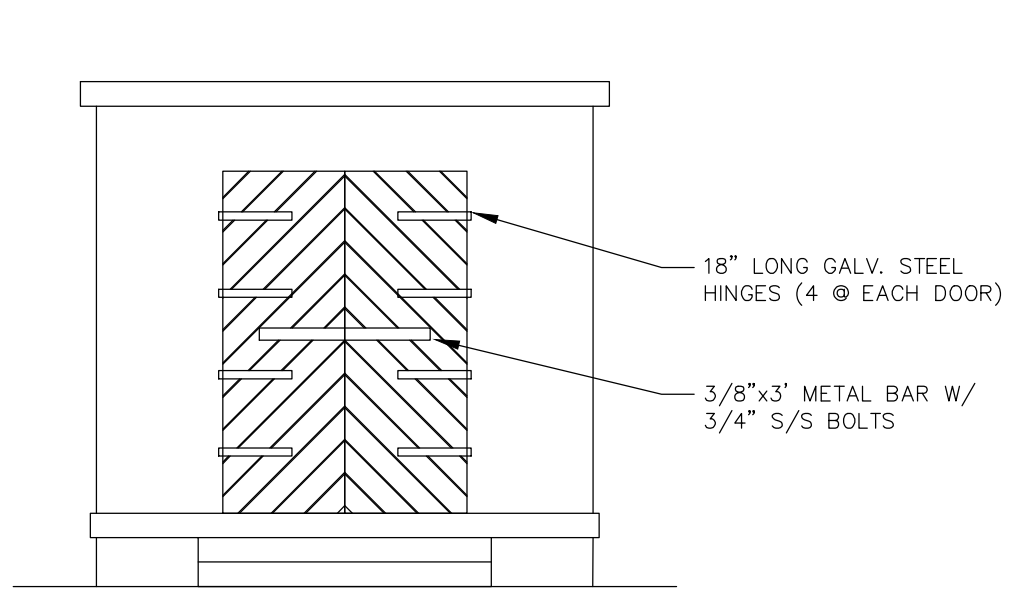


FRONT ELEVATION
Scale: 1/4" = 1'-0"

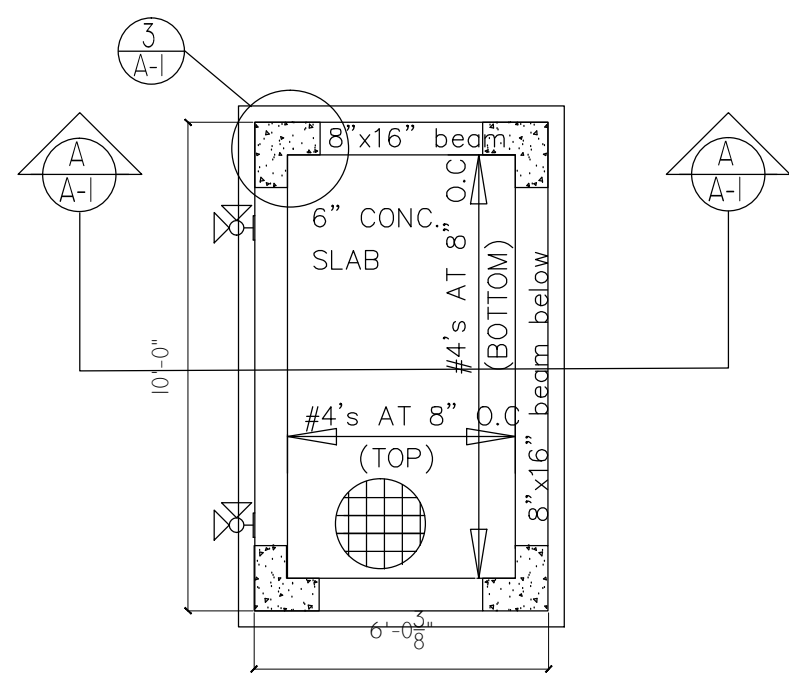


CONC. ROOF PLAN
Scale: 1/4" = 1'-0"

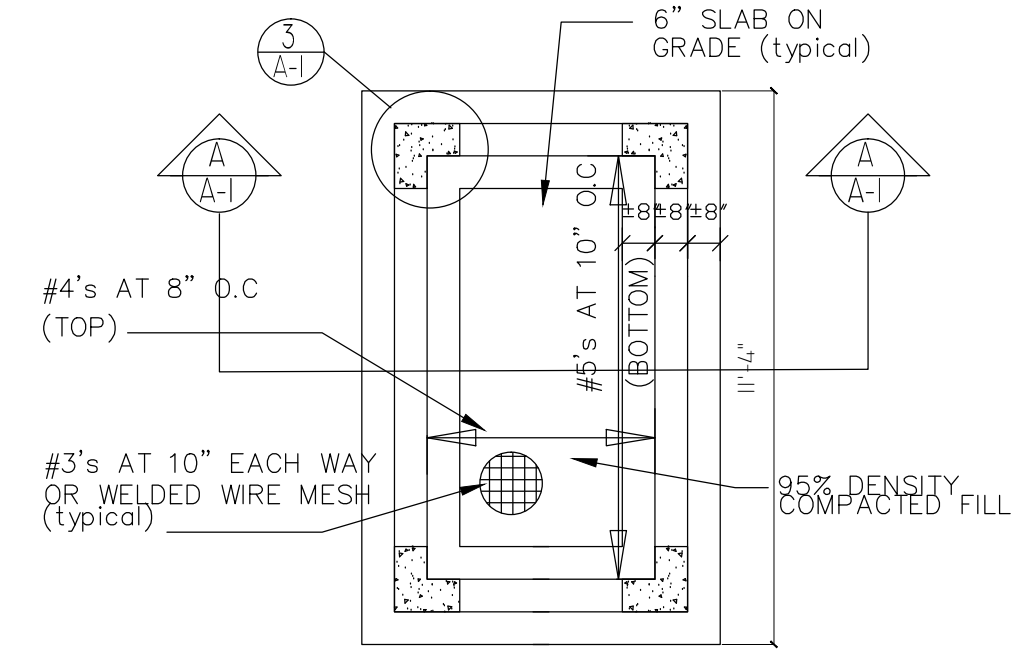


FOUNDATION PLAN
Scale: 1/4" = 1'-0"

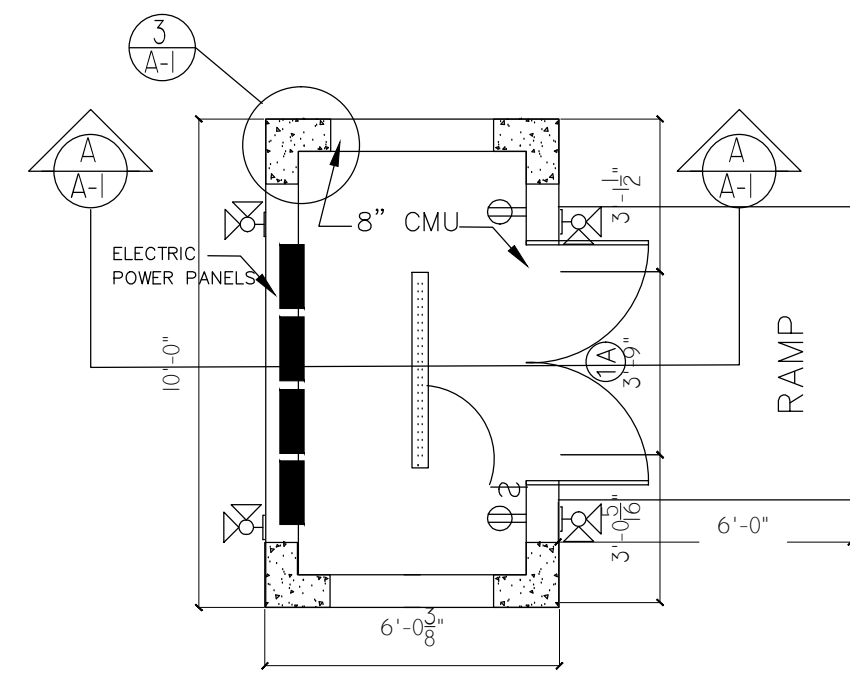


FLOOR PLAN
Scale: 1/4" = 1'-0"

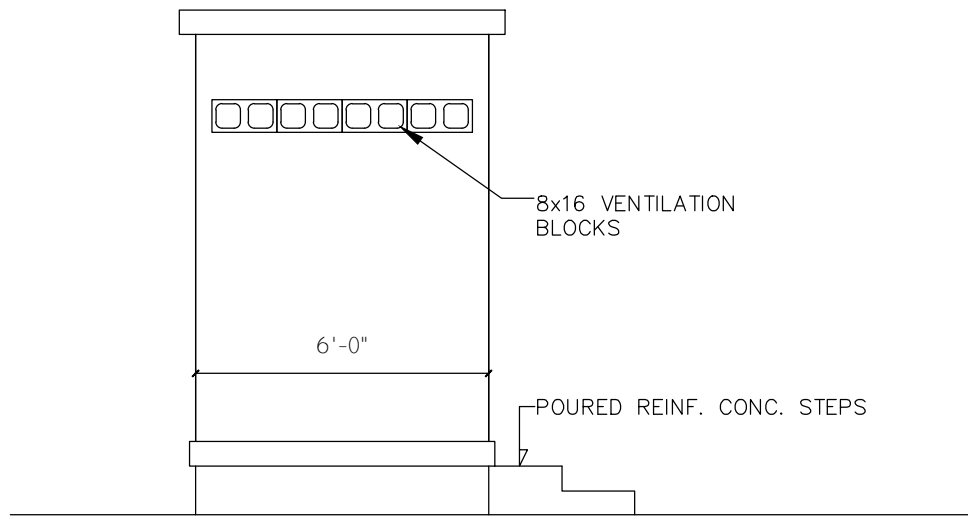


LEFT ELEVATION
Scale: 1/4" = 1'-0"

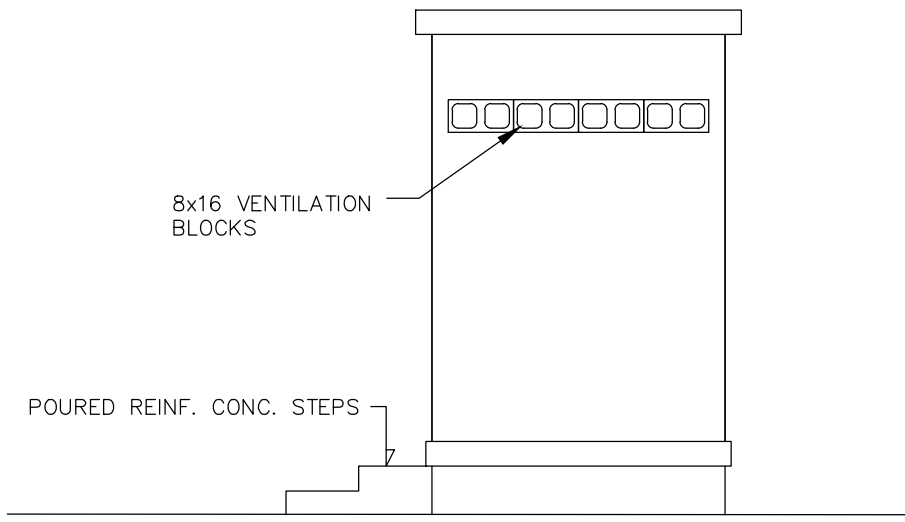


RIGHT ELEVATION
Scale: 1/4" = 1'-0"

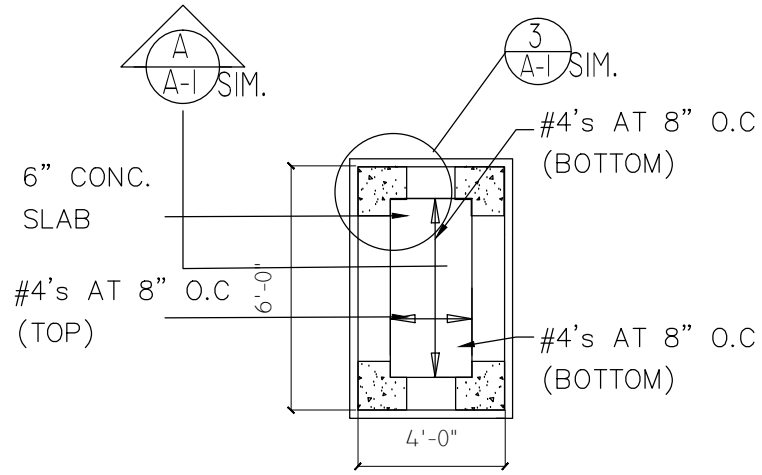


CONC. ROOF PLAN
Scale: 1/4" = 1'-0"

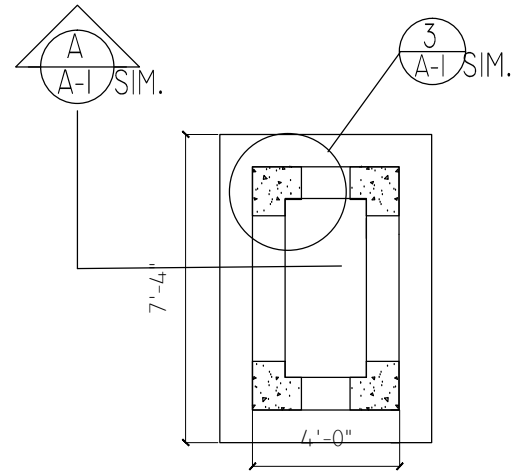


FOUNDATION PLAN
Scale: 1/4" = 1'-0"

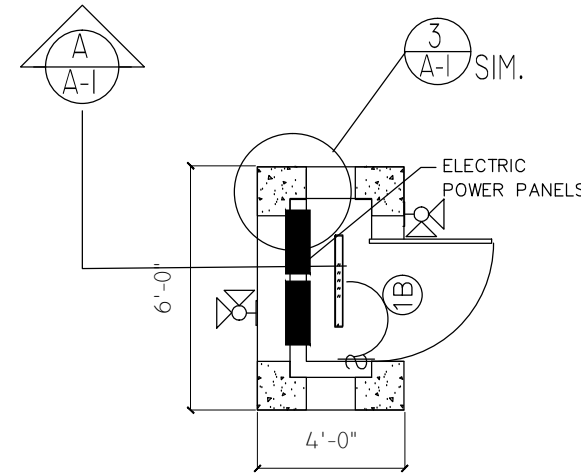


FLOOR PLAN
Scale: 1/4" = 1'-0"

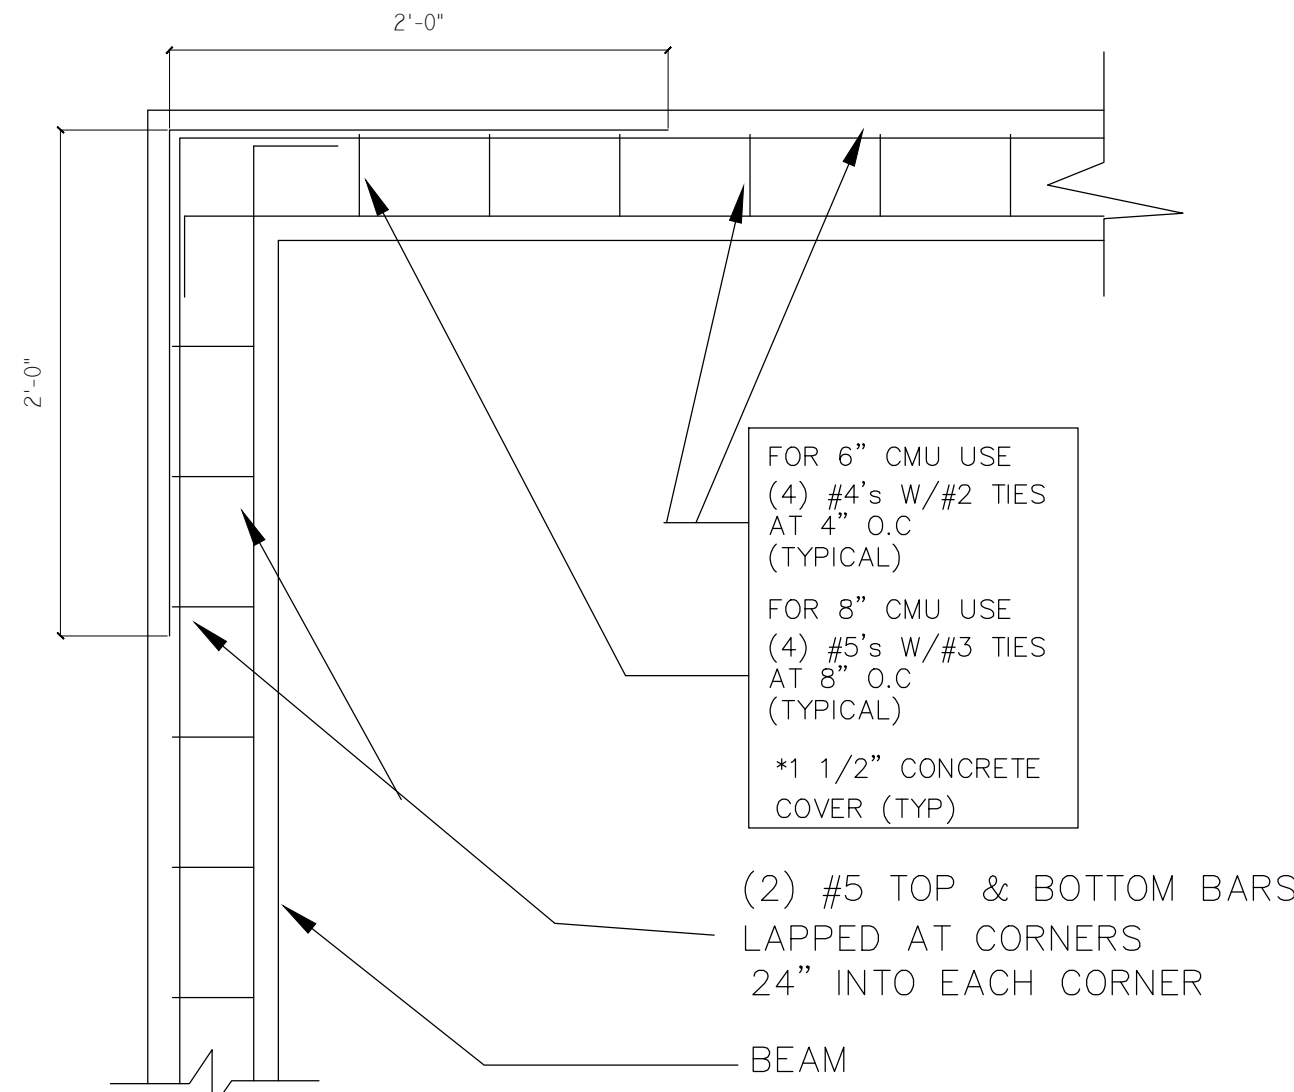


4 BOND BEAM DETAIL @ CORNER
Scale: 1" = 1'-0"

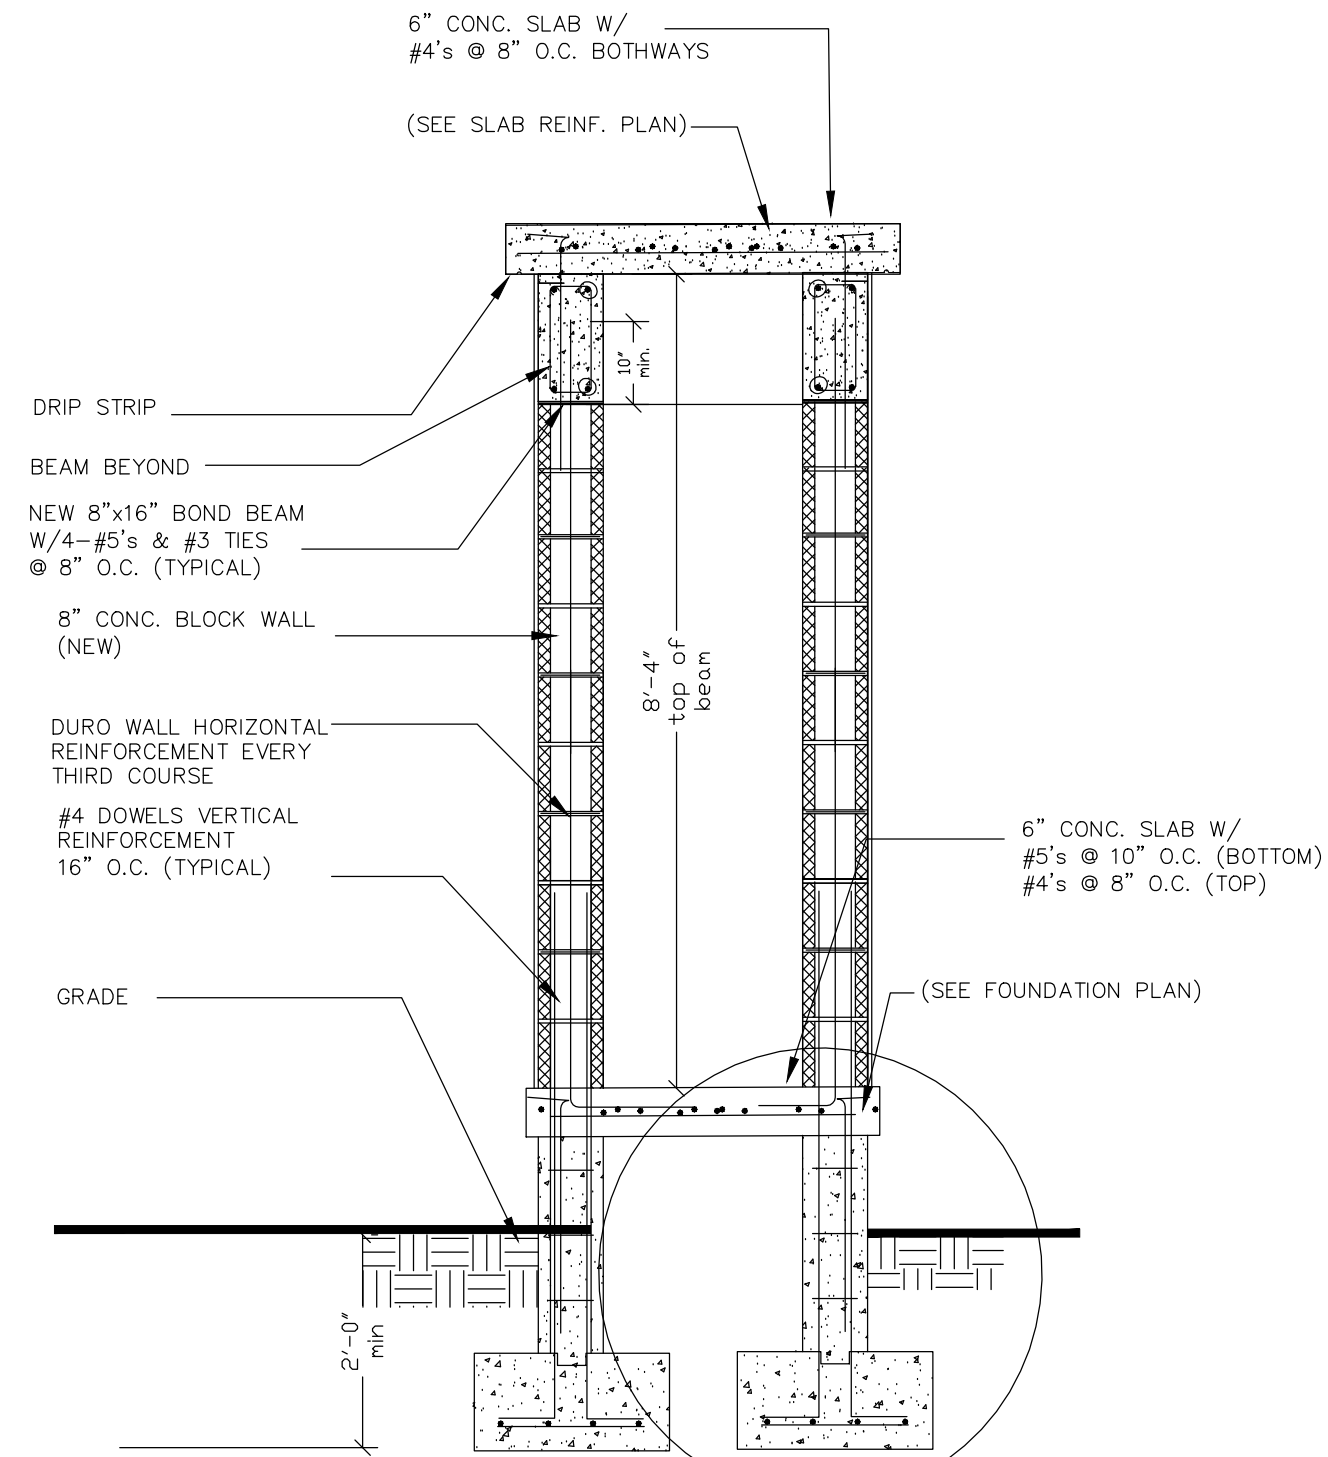


SECTION A-A
Scale: 1/2" = 1'-0"

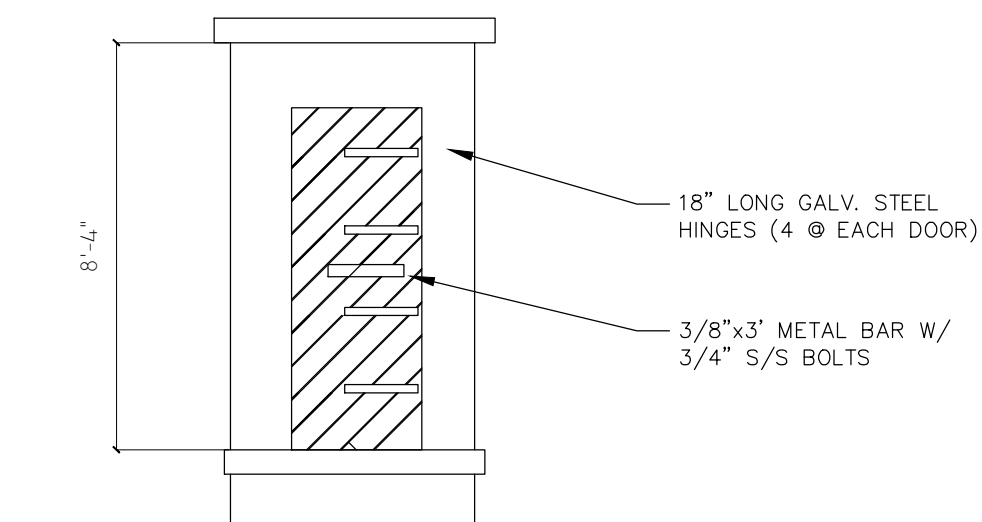


FRONT ELEVATION
Scale: 1/4" = 1'-0"

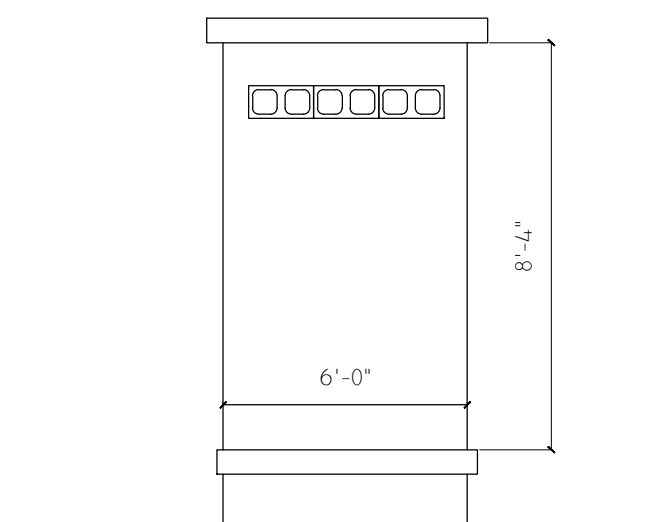


REAR ELEVATION
Scale: 1/4" = 1'-0"

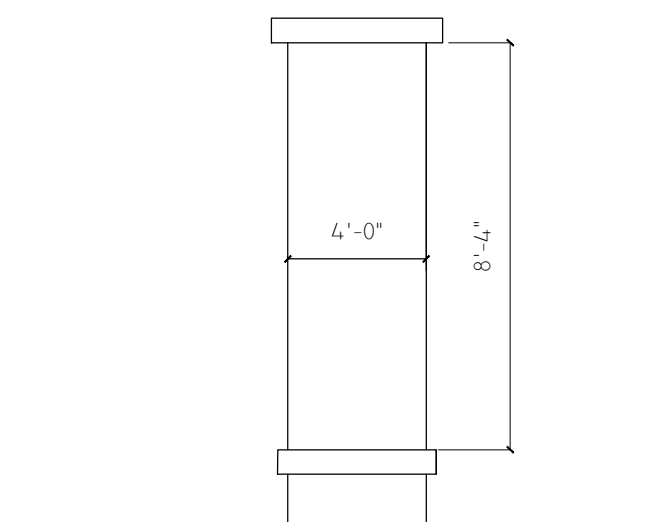


SIDE ELEVATION
Scale: 1/4" = 1'-0"

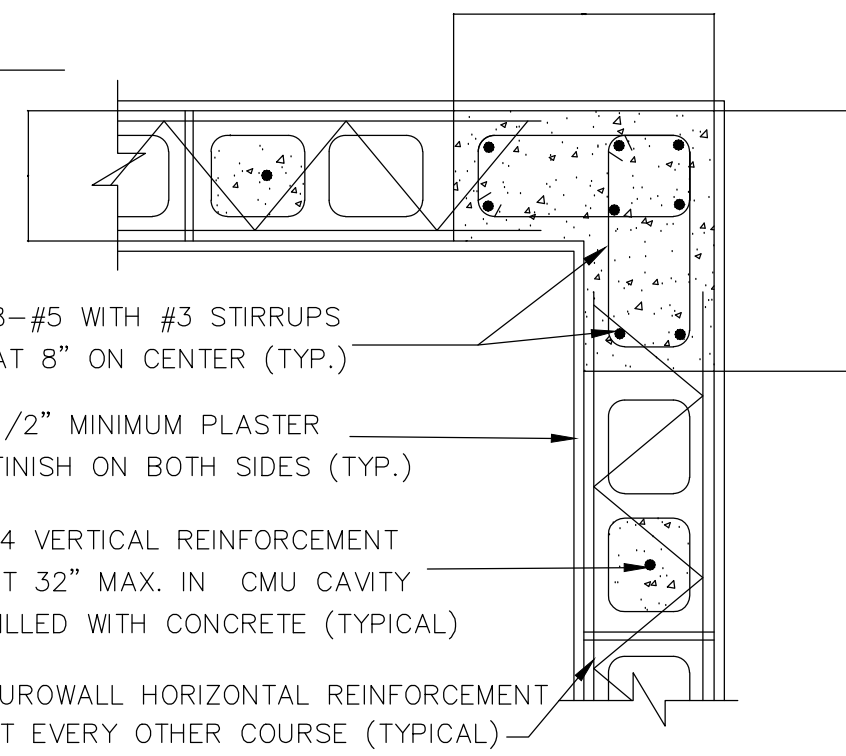

3 CONCRETE COLUMN CORNER DETAIL
Scale: 1" = 1'-0"

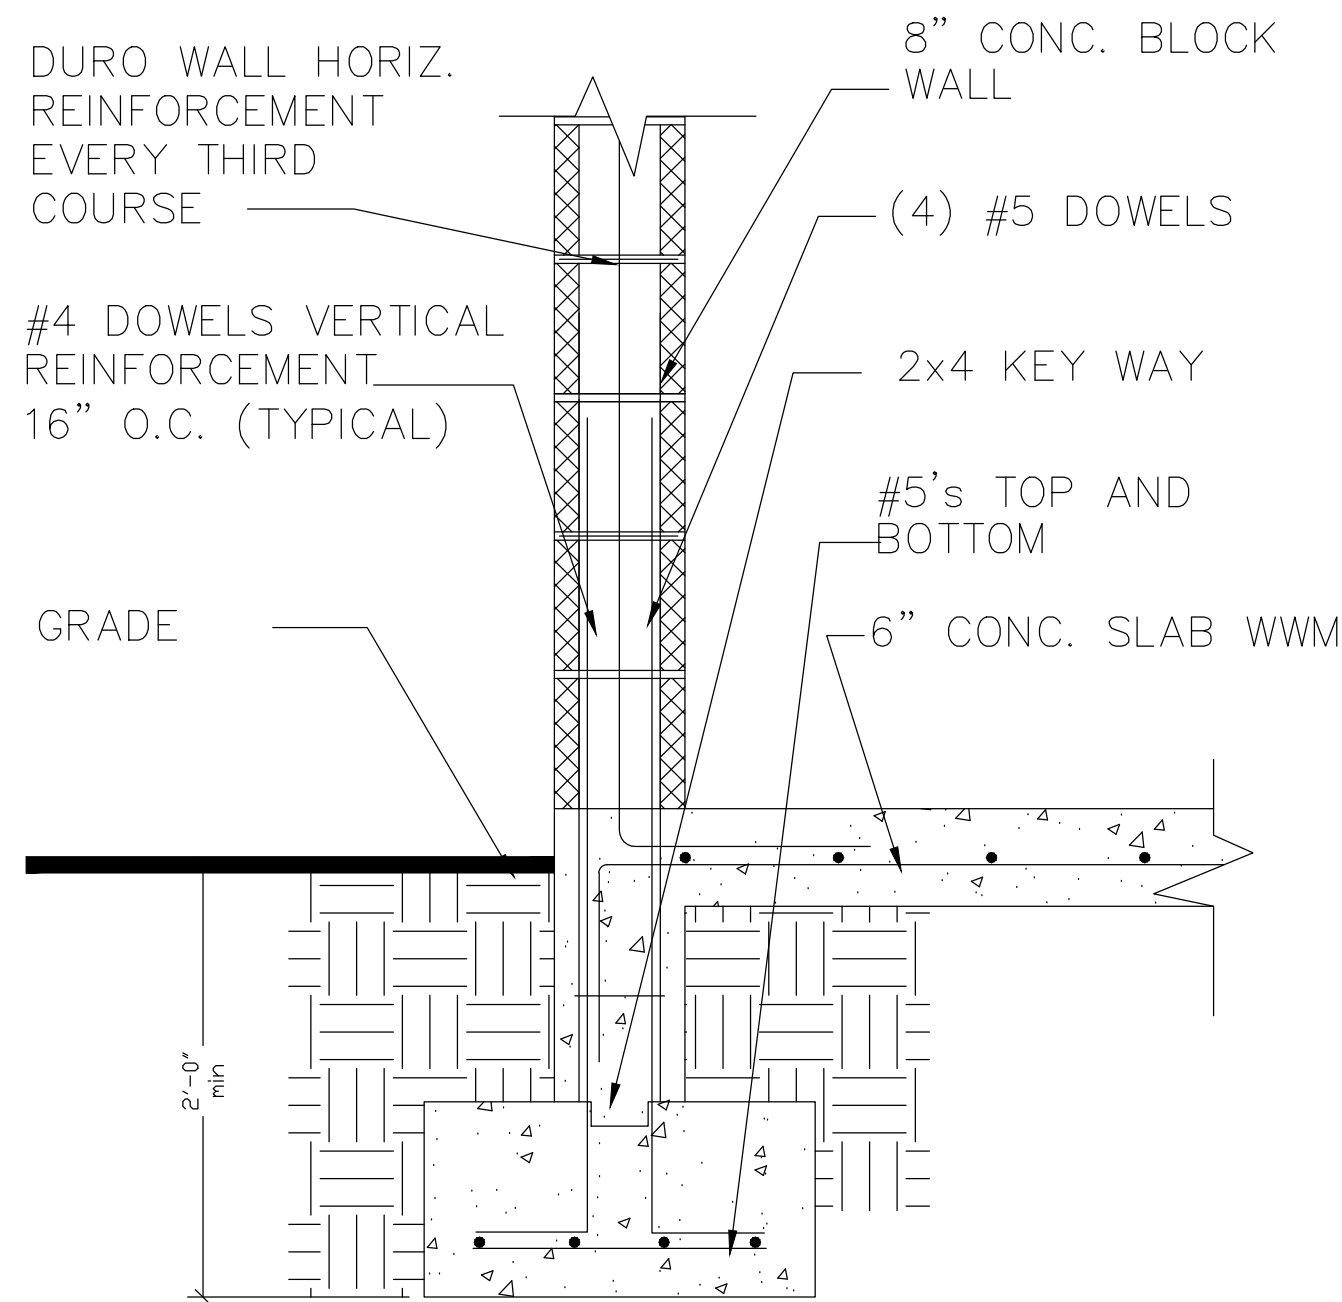

2 FOOTING DETAIL
Scale: 1" = 1'-0"

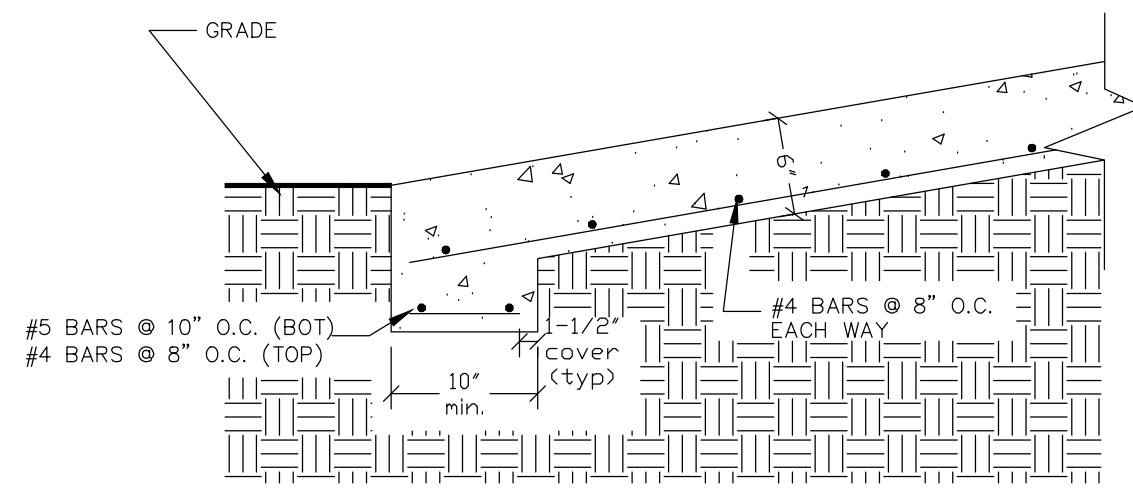

1 RAMP DETAIL
Scale: 3/4" = 1'-0"

DOOR SCHEDULE			
TYPE	HEAD-HEIGHT	WIDTH	COMMENTS
1A	7'-0"	2'-6"	CUSTOM
1B	7'-0"	2'-6"	CUSTOM

ELECTRICAL LEGEND	
	SINGLE POLE LIGHT SWITCH
	DUPLEX RECEPTACLE OUTLET
	WEATHER PROTECTED RECEPTACLE OUTLET
	EXTERIOR WALL MOUNTED SPOTLIGHT FIXTURE
	FLUORESCENT LIGHT FIXTURE
	ELECTRIC POWER PANEL