

NO.	DATE	REVISIONS	REMARKS

ROOF FRAMING PLAN AND ELECTRICAL FLOOR PLAN	PROPOSED BATHROOM AND CONCESSION BUILDINGS FOR: IEKHS TRACK & FIELD ATHLETIC FACILITY OWNER: VIRGIN ISLANDS DEPARTMENT OF EDUCATION No. 172 ESTATE NAZARETH, NO.1 RED HOOK QUARTER, STT USVI
---	---

DRAWN BY:	LND
CHECKED BY:	EJB
APPROVED BY:	EJB
CONTRACT NO.:	CONTRACT.NO.
PROJECT NO.:	PROJ.NO.
DATE:	DEC 15 2015





ELECTRICAL LEGEND

NOTE: FAN & LIGHT SHALL OPERATE ON SEPARATE SWITCHES

ROOF FRAMING PLAN

SCALE: 1/4" = 1'-0"

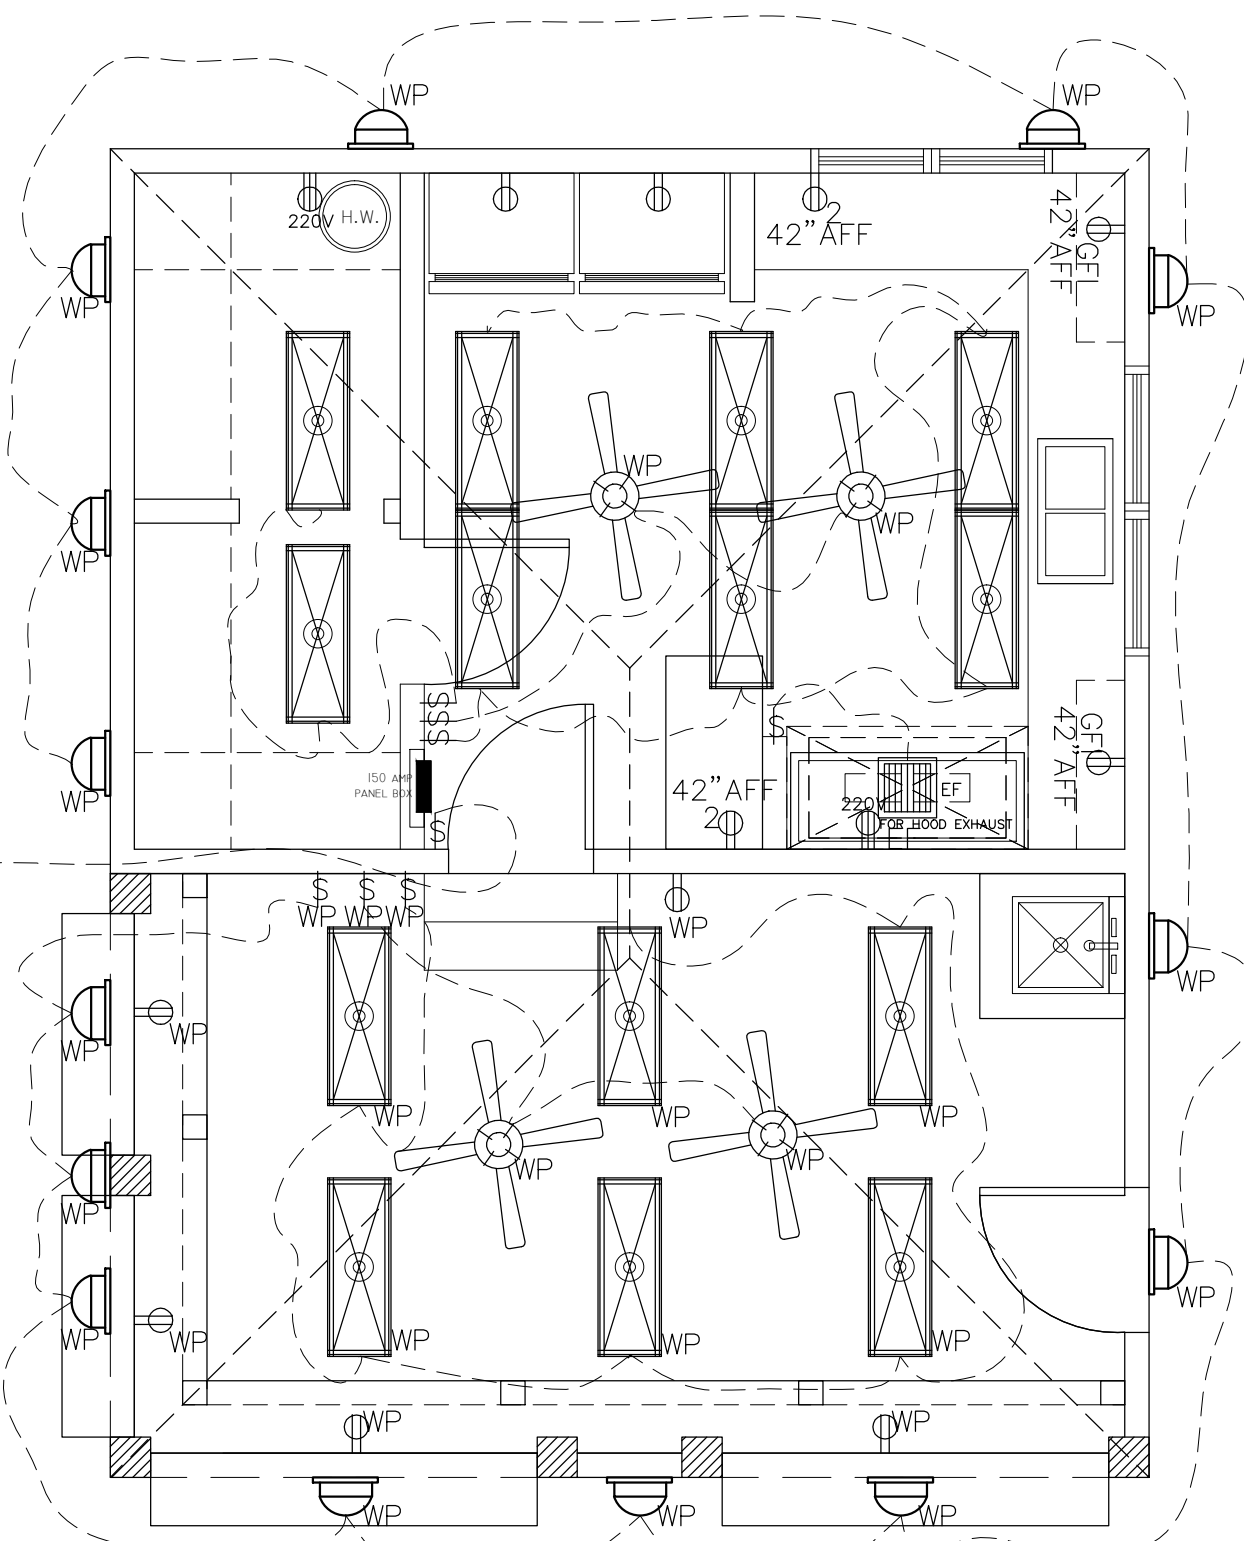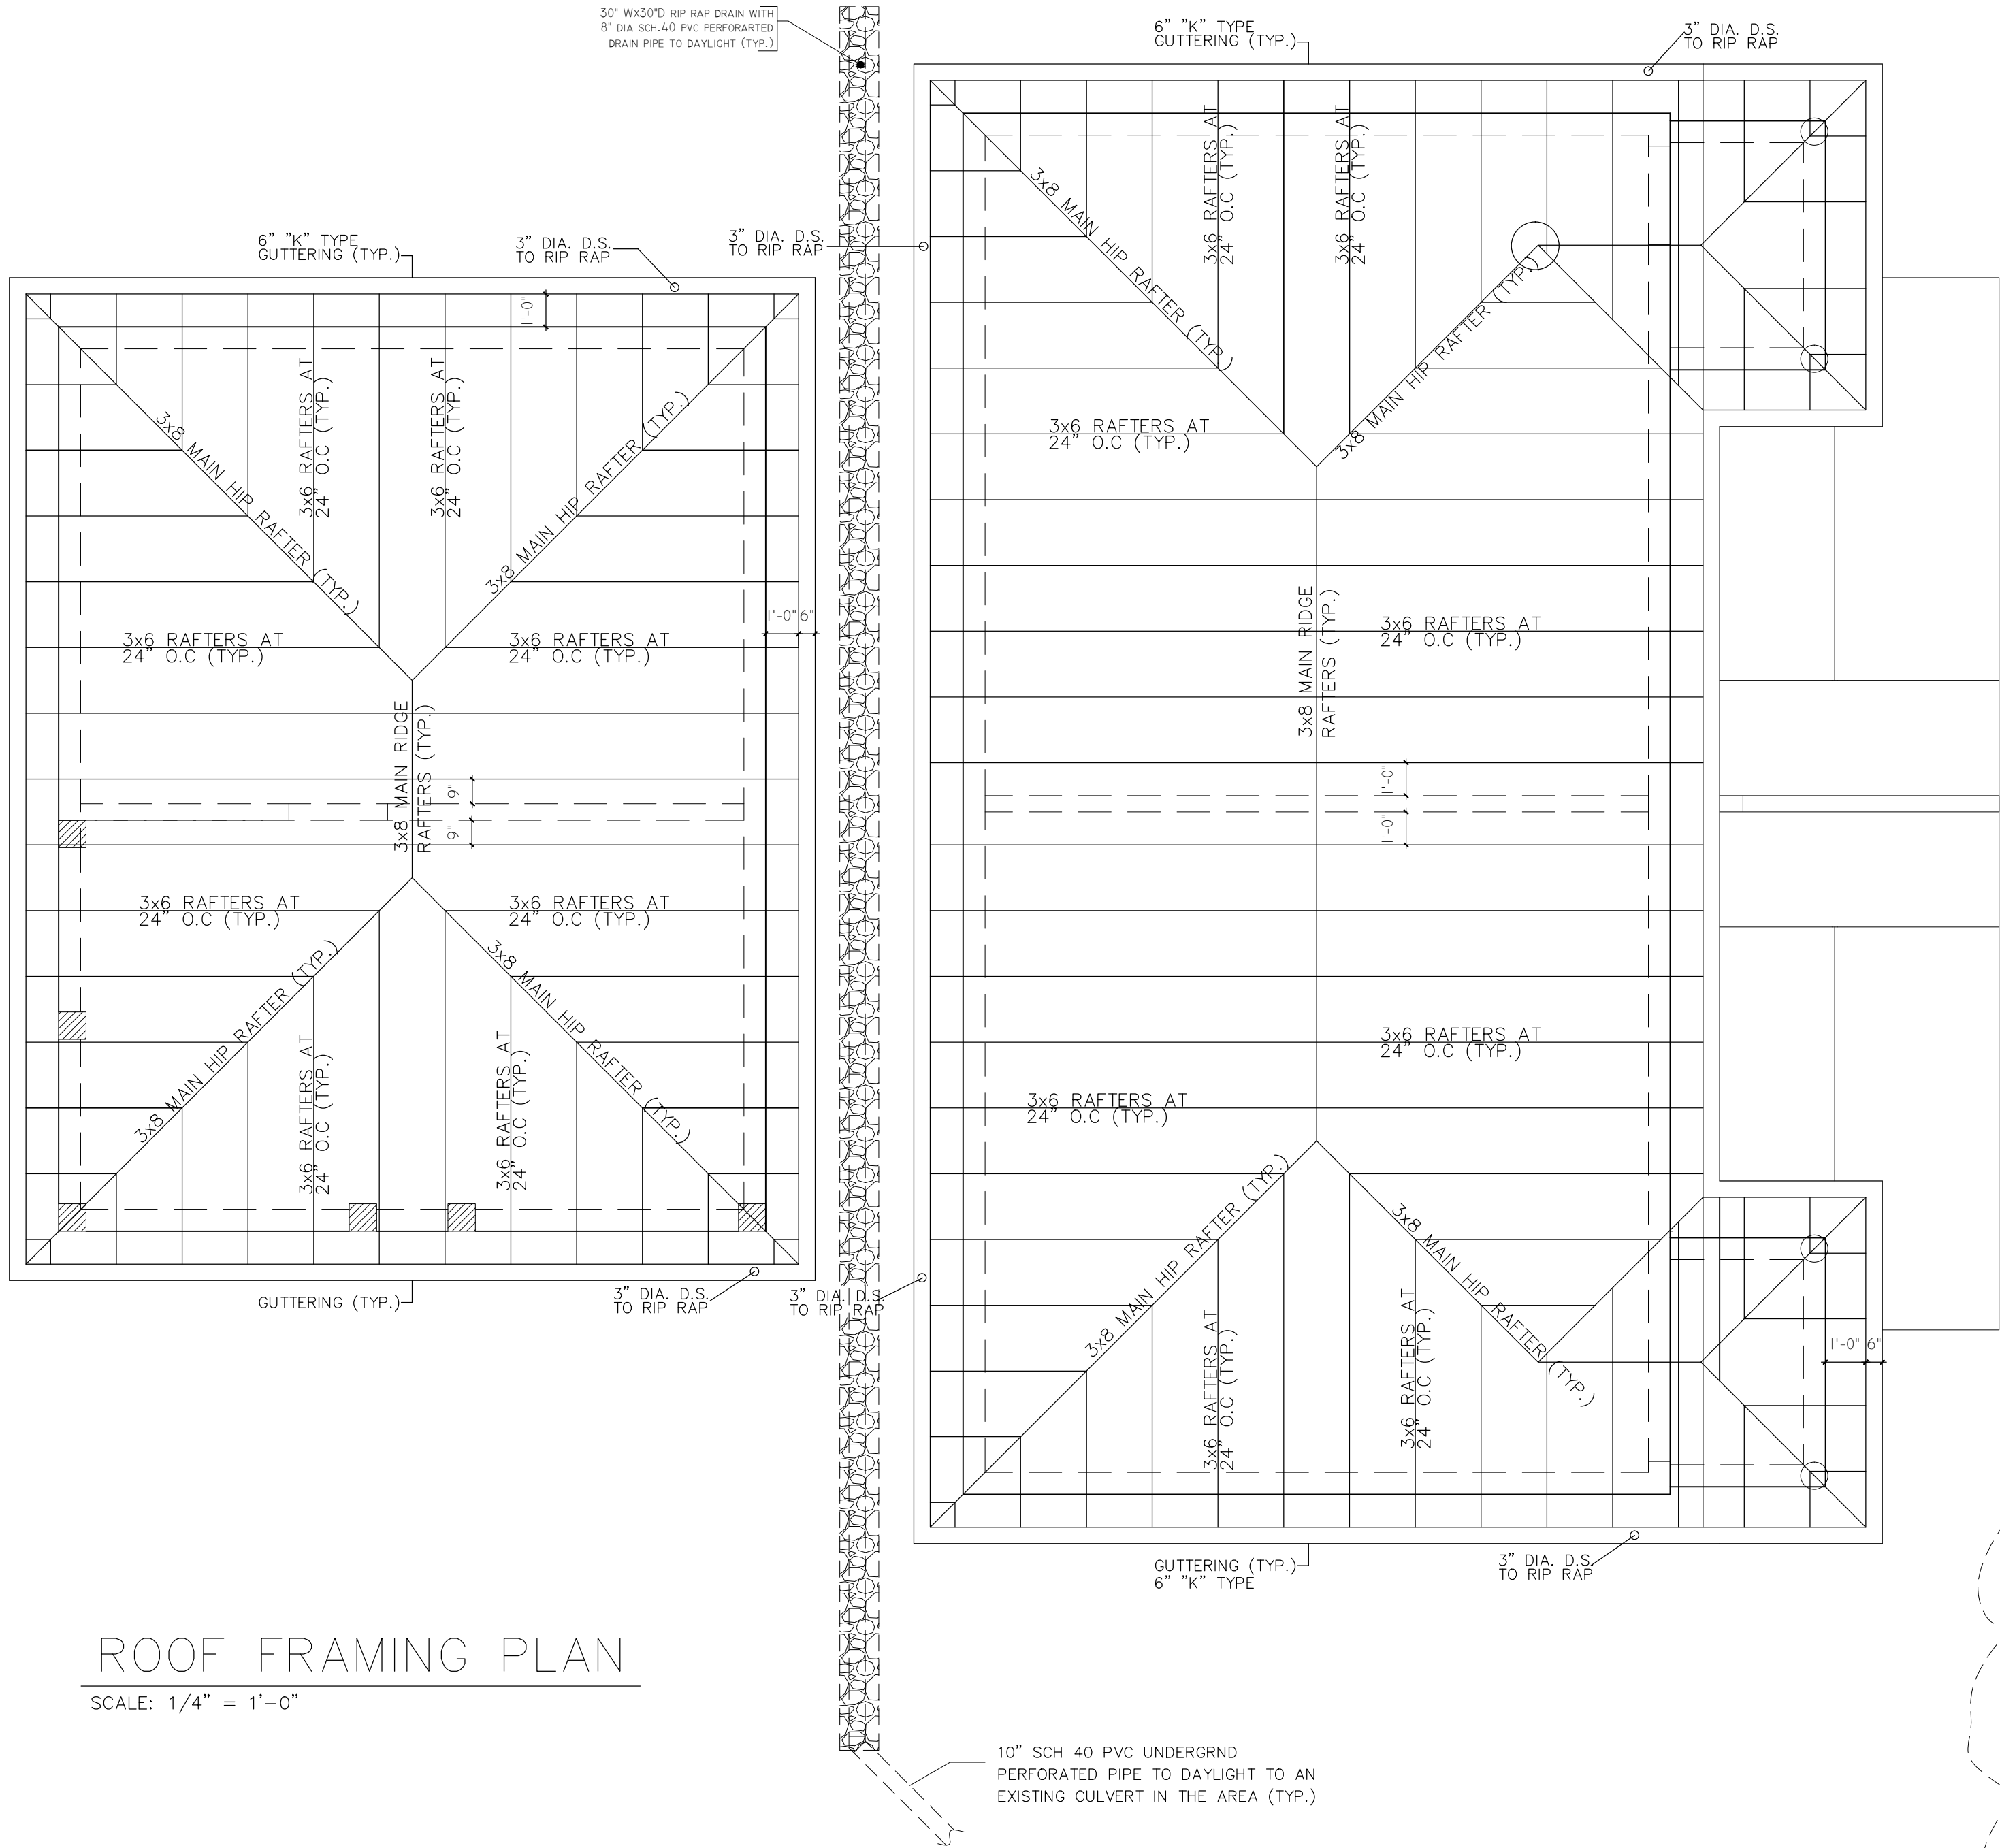

ELECTRICAL PLAN

SCALE: 1/4" = 1'-0"

- NOTES:
- CONTRACTOR SHALL ENSURE THAT ALL ELECTRICAL WORK SHALL ADHERE TO CURRENT INTERNATIONAL AND LOCAL ELECTRICAL CODES
 - CONTRACTOR SHALL CONTACT WAPA AND ARRANGE FOR ESTABLISHING BY WHATEVER LEGAL MEANS ARE REQUIRED, TO CONNECT POWER TO THE 2 BUILDINGS AND ANCILLIARY AREAS FOR THE PROJECT.

WHILE EVERY ATTEMPT HAS BEEN MADE IN THE PREPARATION OF THIS PLAN TO AVOID MISTAKES, THE A/E CANNOT GUARANTEE AGAINST HUMAN ERROR. THE CONTRACTOR ON THE JOB MUST CHECK ALL DIMENSIONS, DETAILS, AND THE CONSTRUCTION SITE AND NOTIFY THE ARCHITECT OF ANY DISCREPANCIES NOTED ON THE DRAWINGS OR IN THE FIELD. IT IS THE CONTRACTOR'S RESPONSIBILITY TO ENSURE THAT THE A/E IS NOTIFIED.