
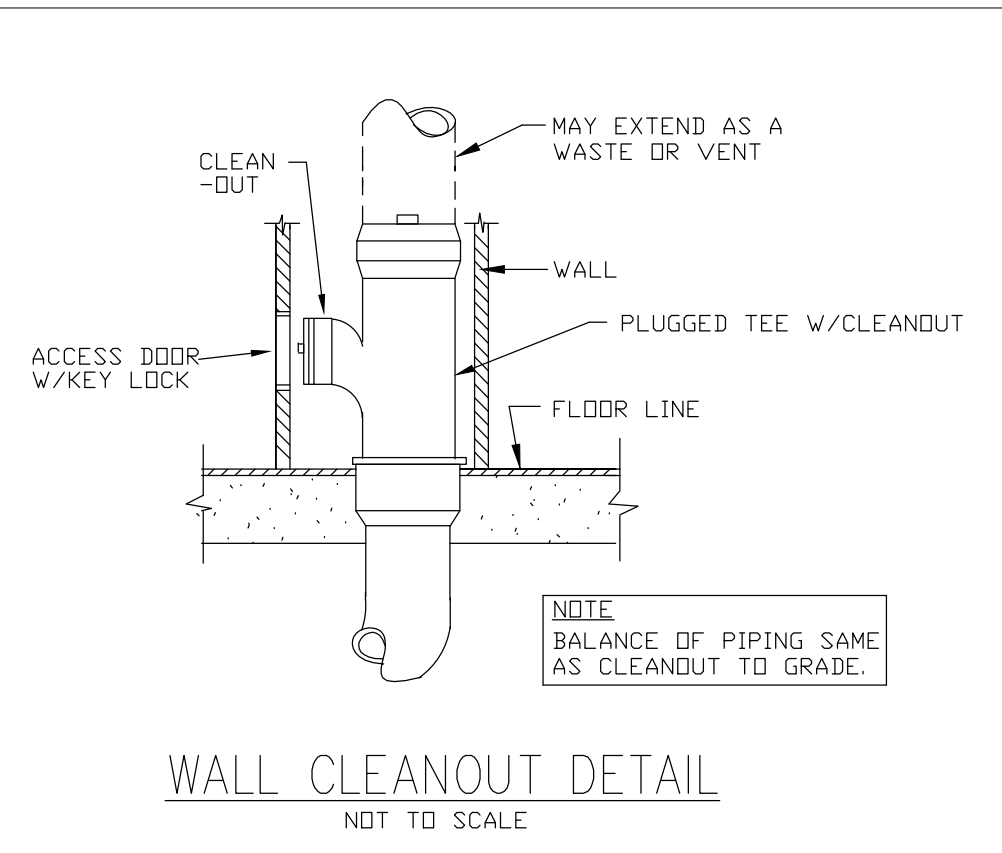
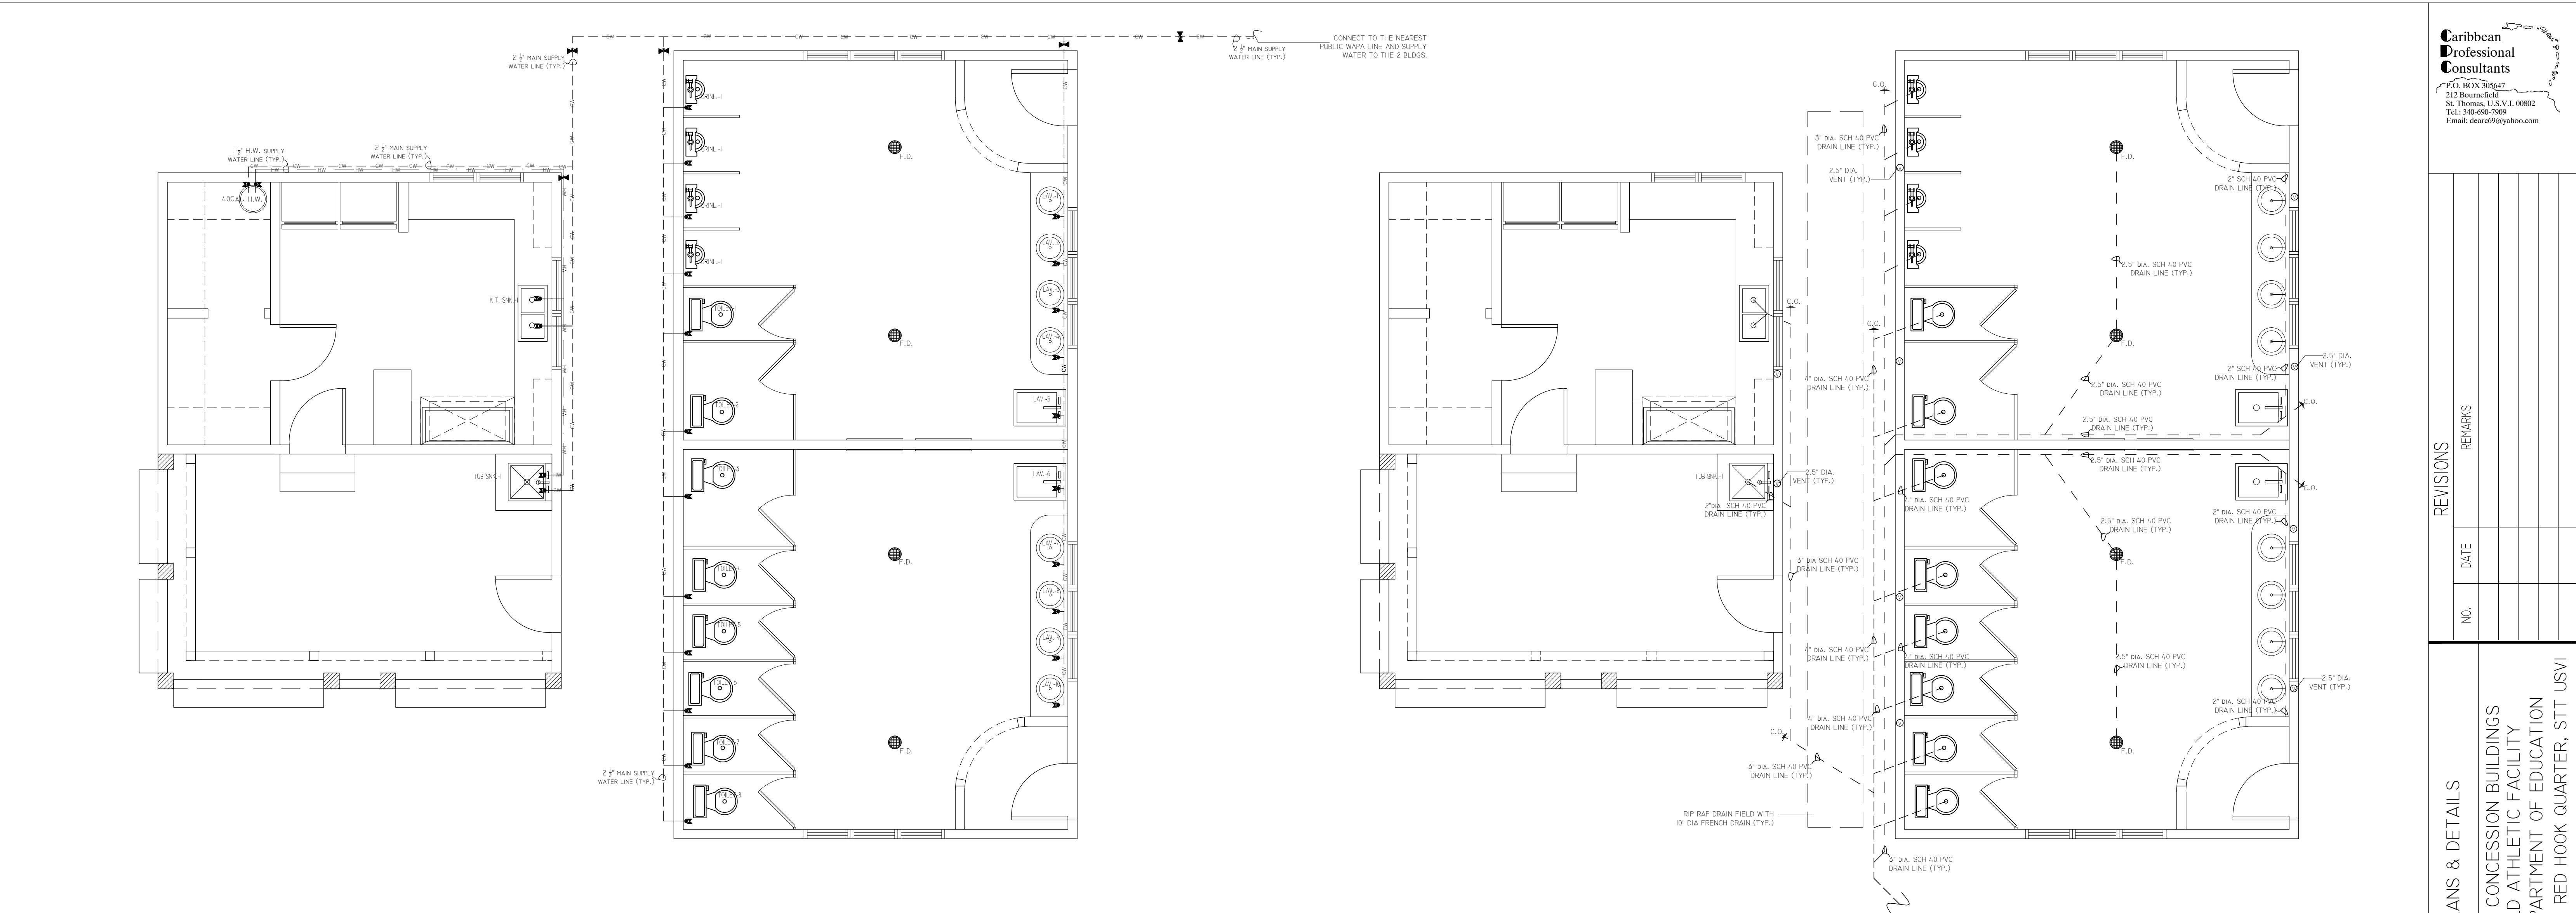


NO.	DATE	REVISIONS

PLUMBING PLANS & DETAILS	
PROPOSED BATHROOM AND CONCESSION BUILDINGS FOR: IEKHS TRACK & FIELD ATHLETIC FACILITY OWNER: VIRGIN ISLANDS DEPARTMENT OF EDUCATION NO. 172 ESTATE NAZARETH, NO.1 RED HOOK QUARTER, STT USVI	

DRAWN BY:	LND
CHECKED BY:	EJB
APPROVED BY:	EJB

CONTRACT NO.:	CONTRACT.NO.
PROJECT NO.:	PROJ.NO.
DATE:	DEC 15 2015

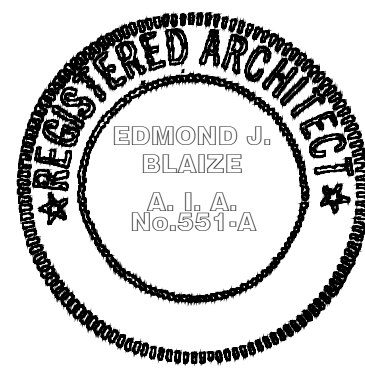

NOTE: PROVIDE SEISMIC RESTRAINTS FOR PIPING AS FOLLOWS:
• 1\"/>

