
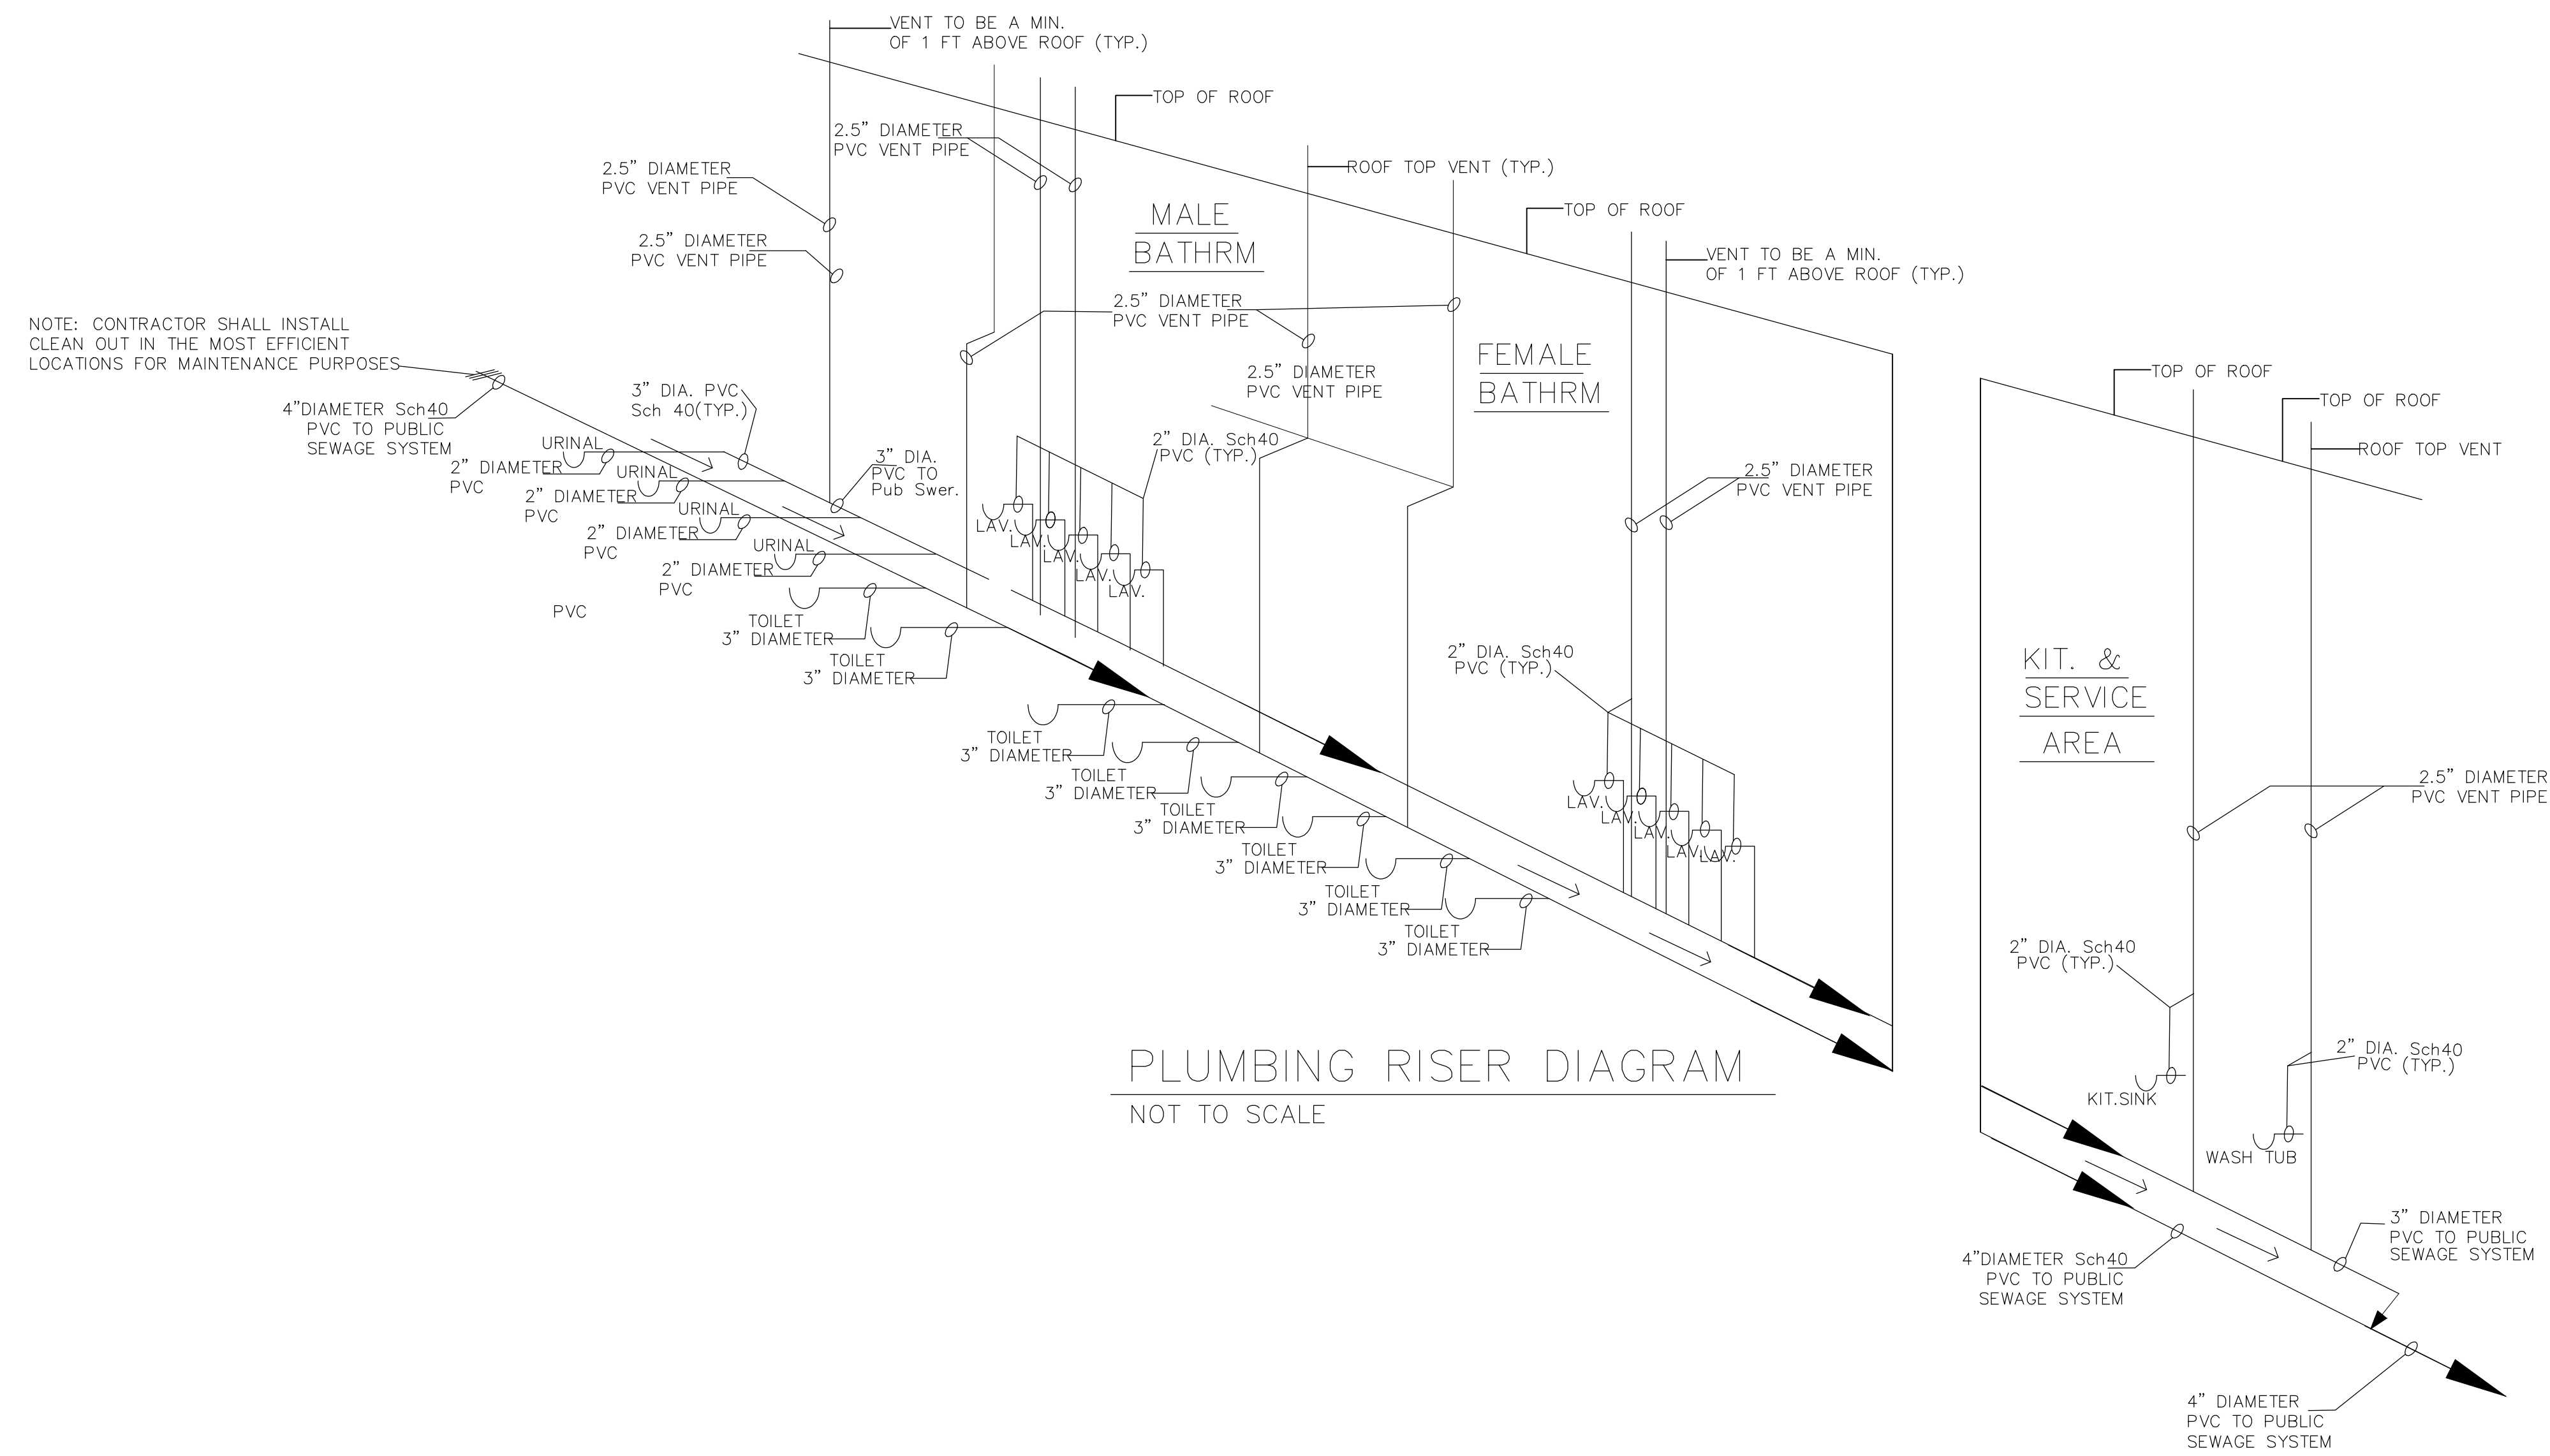


BATHROOM BUILDING HOT AND COLD WATER RISER DIAG.

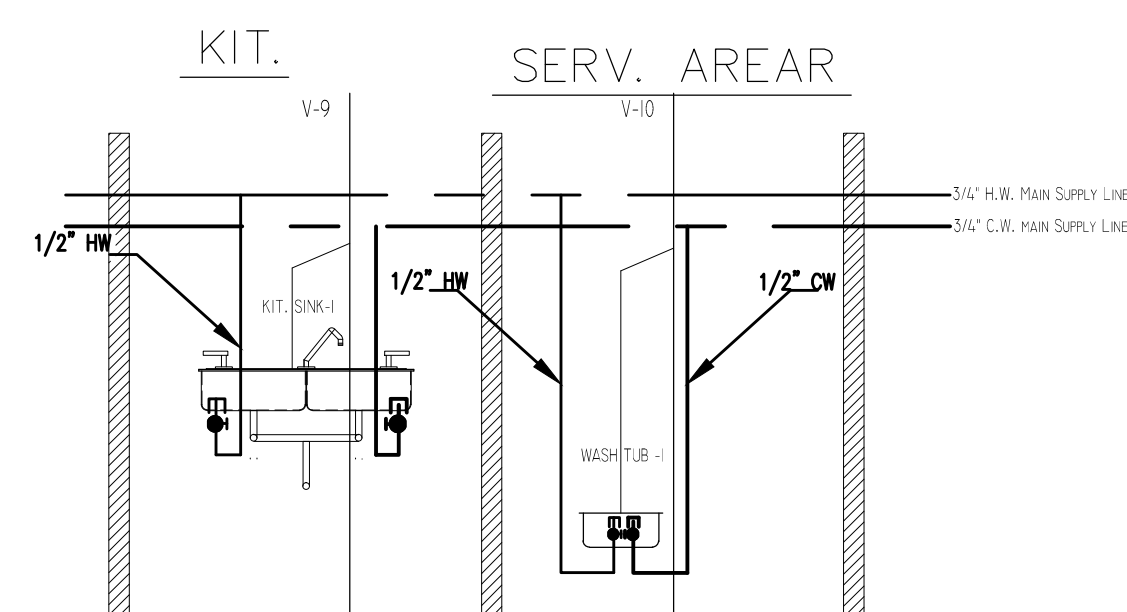

CONCESSION BUILDING HOT AND COLD WATER RISER DIAG.

WHILE EVERY ATTEMPT HAS BEEN MADE IN THE PREPARATION OF THIS PLAN TO AVOID MISTAKES, THE A/E CANNOT GUARANTEE AGAINST HUMAN ERROR. THE CONTRACTOR ON THE JOB MUST CHECK ALL DIMENSIONS, DETAILS, AND THE CONSTRUCTION SITE AND NOTIFY THE ARCHITECT OF ANY DISCREPANCIES NOTED ON THE DRAWINGS OR IN THE FIELD. IT IS THE CONTRACTOR'S RESPONSIBILITY TO ENSURE THAT THE A/E IS NOTIFIED.

[illegible]

PLUMBING RISER DIAGRAM & PLUMBING DETAILS

PROPOSED BATHROOM AND CONCESSION BUILDINGS
FOR: LEKHS TRACK & FIELD ATHLETIC FACILITY
OWNER: VIRGIN ISLANDS DEPARTMENT OF EDUCATION
No. 172 ESTATE NAZARETH, NO.1 RED HOOK QUARTER, STT

RAWN BY:

LND

CHECKED BY _____

EJB

APPROVED BY _____

EJB

CONTRACT NO.:

CONTRACT.NO.

PROJECT NO.:

PROJ.NO.

DATE:

DEC 15 2015



SHEET NO.:

P.2

SHEET NO. # OF # SHEETS