 
 
 
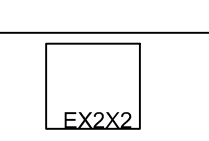
 
 
 



ELECTRICAL SYMBOLS LEGEND & NOTES	
	1X4 EXISTING LIGHT FIXTURE
	DUPLEX SWITCH
	21"X21" VENT AT CEILING
	EXPOSED DUCTING AT CEILING POSSIBLY FOR EXISTING HOOD
	EXISTING 2X2 ACOUSTICAL TILE
	EXISTING CEILING MOUNTED LIGHT FIXTURE
	2X2 EXISTING LIGHT FIXTURE
	EXISTING DUPLEX OUTLET LOCATED ON WALL SURFACE
	EXISTING FLOOR DRAIN
	EXISTING OUTLET/@ FLOOR
	EXISTING FIRE EXTINGUISHER(TO BE PROVIDED BY DOE COMMERCIAL KITCHEN GRADE)
	EXISTING ELECTRICAL PANELS
	EXISTING FIRE SUPPRESSION SYSTEM

ELECTRICAL NOTES

- 1
- CONTRACTOR TO REMOVE ANY LIGHT BULBS THAT ARE IN OPERABLE AND REPLACE WITH NEW AND REPAIR BALLAST AS REQUIRED
- 2
- ESTABLISH IF EXISTING PANEL BOXES ARE CURRENTLY IN USE. IF NOT IN USE CONTRACTOR SHALL REMOVE AND TERMINATE SERVICE OF BOX.
- 3
- CONTRACTOR TO REMOVE ANY EXISTING FLOOR MOUNTED ELECTRICAL BOXES/AND ELECTRICAL PANEL BOXES THAT ARE NOT BEING UTILIZED AS PER THE NEW EQUIPMENT SPECIFICATIONS. THEY SHALL BE REMOVED AND OR CAPPED .
- 4
- REMOVE ELECTRICAL PANEL BOX AND RELOCATE TO WALL NOTED ON THE PLAN. UPGRADE PANEL BOX AS PER CODE AND EXISTING REQUIREMENTS FOR THE EXISTING MIXER THAT WILL REMAIN
- 5
- ELECTRICAL PANEL TO REMAIN AT THIS LOCATION CONTRACTOR SHALL VERIFY IF PANEL BOX IS OPERABLE AND OR UTILIZED BY ANY EQUIPMENT AND NOTIFY THE ARCHITECT.
- 6
- CONTRACTOR TO VERIFY IF ALL FLOOR MOUNTED AND DUPLEX OUTLETS AND SWITCHES ARE OPERABLE. IF NOT REQUIRED FOR NEW KITCHEN EQUIPMENT CONTRACTOR SHALL REMOVE AND OR CAP AS NECESSARY.
- 7
- CONTRACTOR TO REMOVE EXISTING LIGHT FIXTURE AND REPLACE WITH EQUAL SURFACE MOUNTED FIXTURE OR BETTER.
- 8
- CONTRACTOR VERIFY EXISTING EXHAUST HOOD AND EXHAUST HOOD SWITCH IS OPERABLE AND IN COMPLIANCE WITH NFPA CODES . IF NON OPERABLE CONTRACTOR SHALL REPAIR EXISTING EXHAUST HOOD AND SWITCH AND ENSURE IT IS OPERABLE TO ACCOMODATE EQUIPMENT AS PER MANUFACTURER'S SPECIFICATIONS.
- 9
- REMOVE AND REPLACE EXISTING FIRE SUPPRESSION SYSTEM. REPLACE WITH NEW FIRE SUPPRESSION SYSTEM AS SPECIFIED AND PROPERLY INSTALL WITH EXISTING HOOD IN ACCORDANCE WITH EQUIPMENT SPECIFICAIONS AND IN COMPLIANCE WITH NFPA,NEC. LOCAL BUILDING CODES.

- 10
- CONTRACTOR SHALL INSPECT ALL DUCTWORK IN CEILING AND ESTABLISH IF GRILLS IN THE CEILING ARE OPERABLE. CONTRACTOR SHALL NOTIFY DEPARTMENT OF EDUCATION AND ARCHITECT TO ESTABLISH WHAT SHOULD BE THE CURRENT AIR CONDITIONING SYSTEM.
- 11
- EXISTING FIRE EXTINGUISHER TO BE REMOVED AND REPLACE WITH COMMERICAL GRADE EXTINGUISHERS PROVIDED BY DEPT. OF EDUCATION
- 12
- EXISTING SOAP DISPENSING CARTRIDGES FOR DISHWASHER TO BE REMOVED AND REPLACED WITH PROPER INSTITUTIONAL TYPE OF DISPENSING SYSTEM AS PER THE MANUFACTURERS SPECIFICATIONS TO THE NEW DISHWASHER
- 13
- CONTRACTOR NEEDS TO VERIFY EXISTING ELECTRICAL BOX AND DETERIMINE IF REQUIRED FOR NEW DISHWASHER IN ACCORDANCE WITH THE SPECIFICATIONS FOR THE NEW DISHWASHER.

CONTRACTOR TO VERIFY ELECTRICAL IF SWITCHES FOR EXISTING EXHAUST HOOD ARE OPERABLE AND REPAIR TO ENSURE PROPER OPERATION

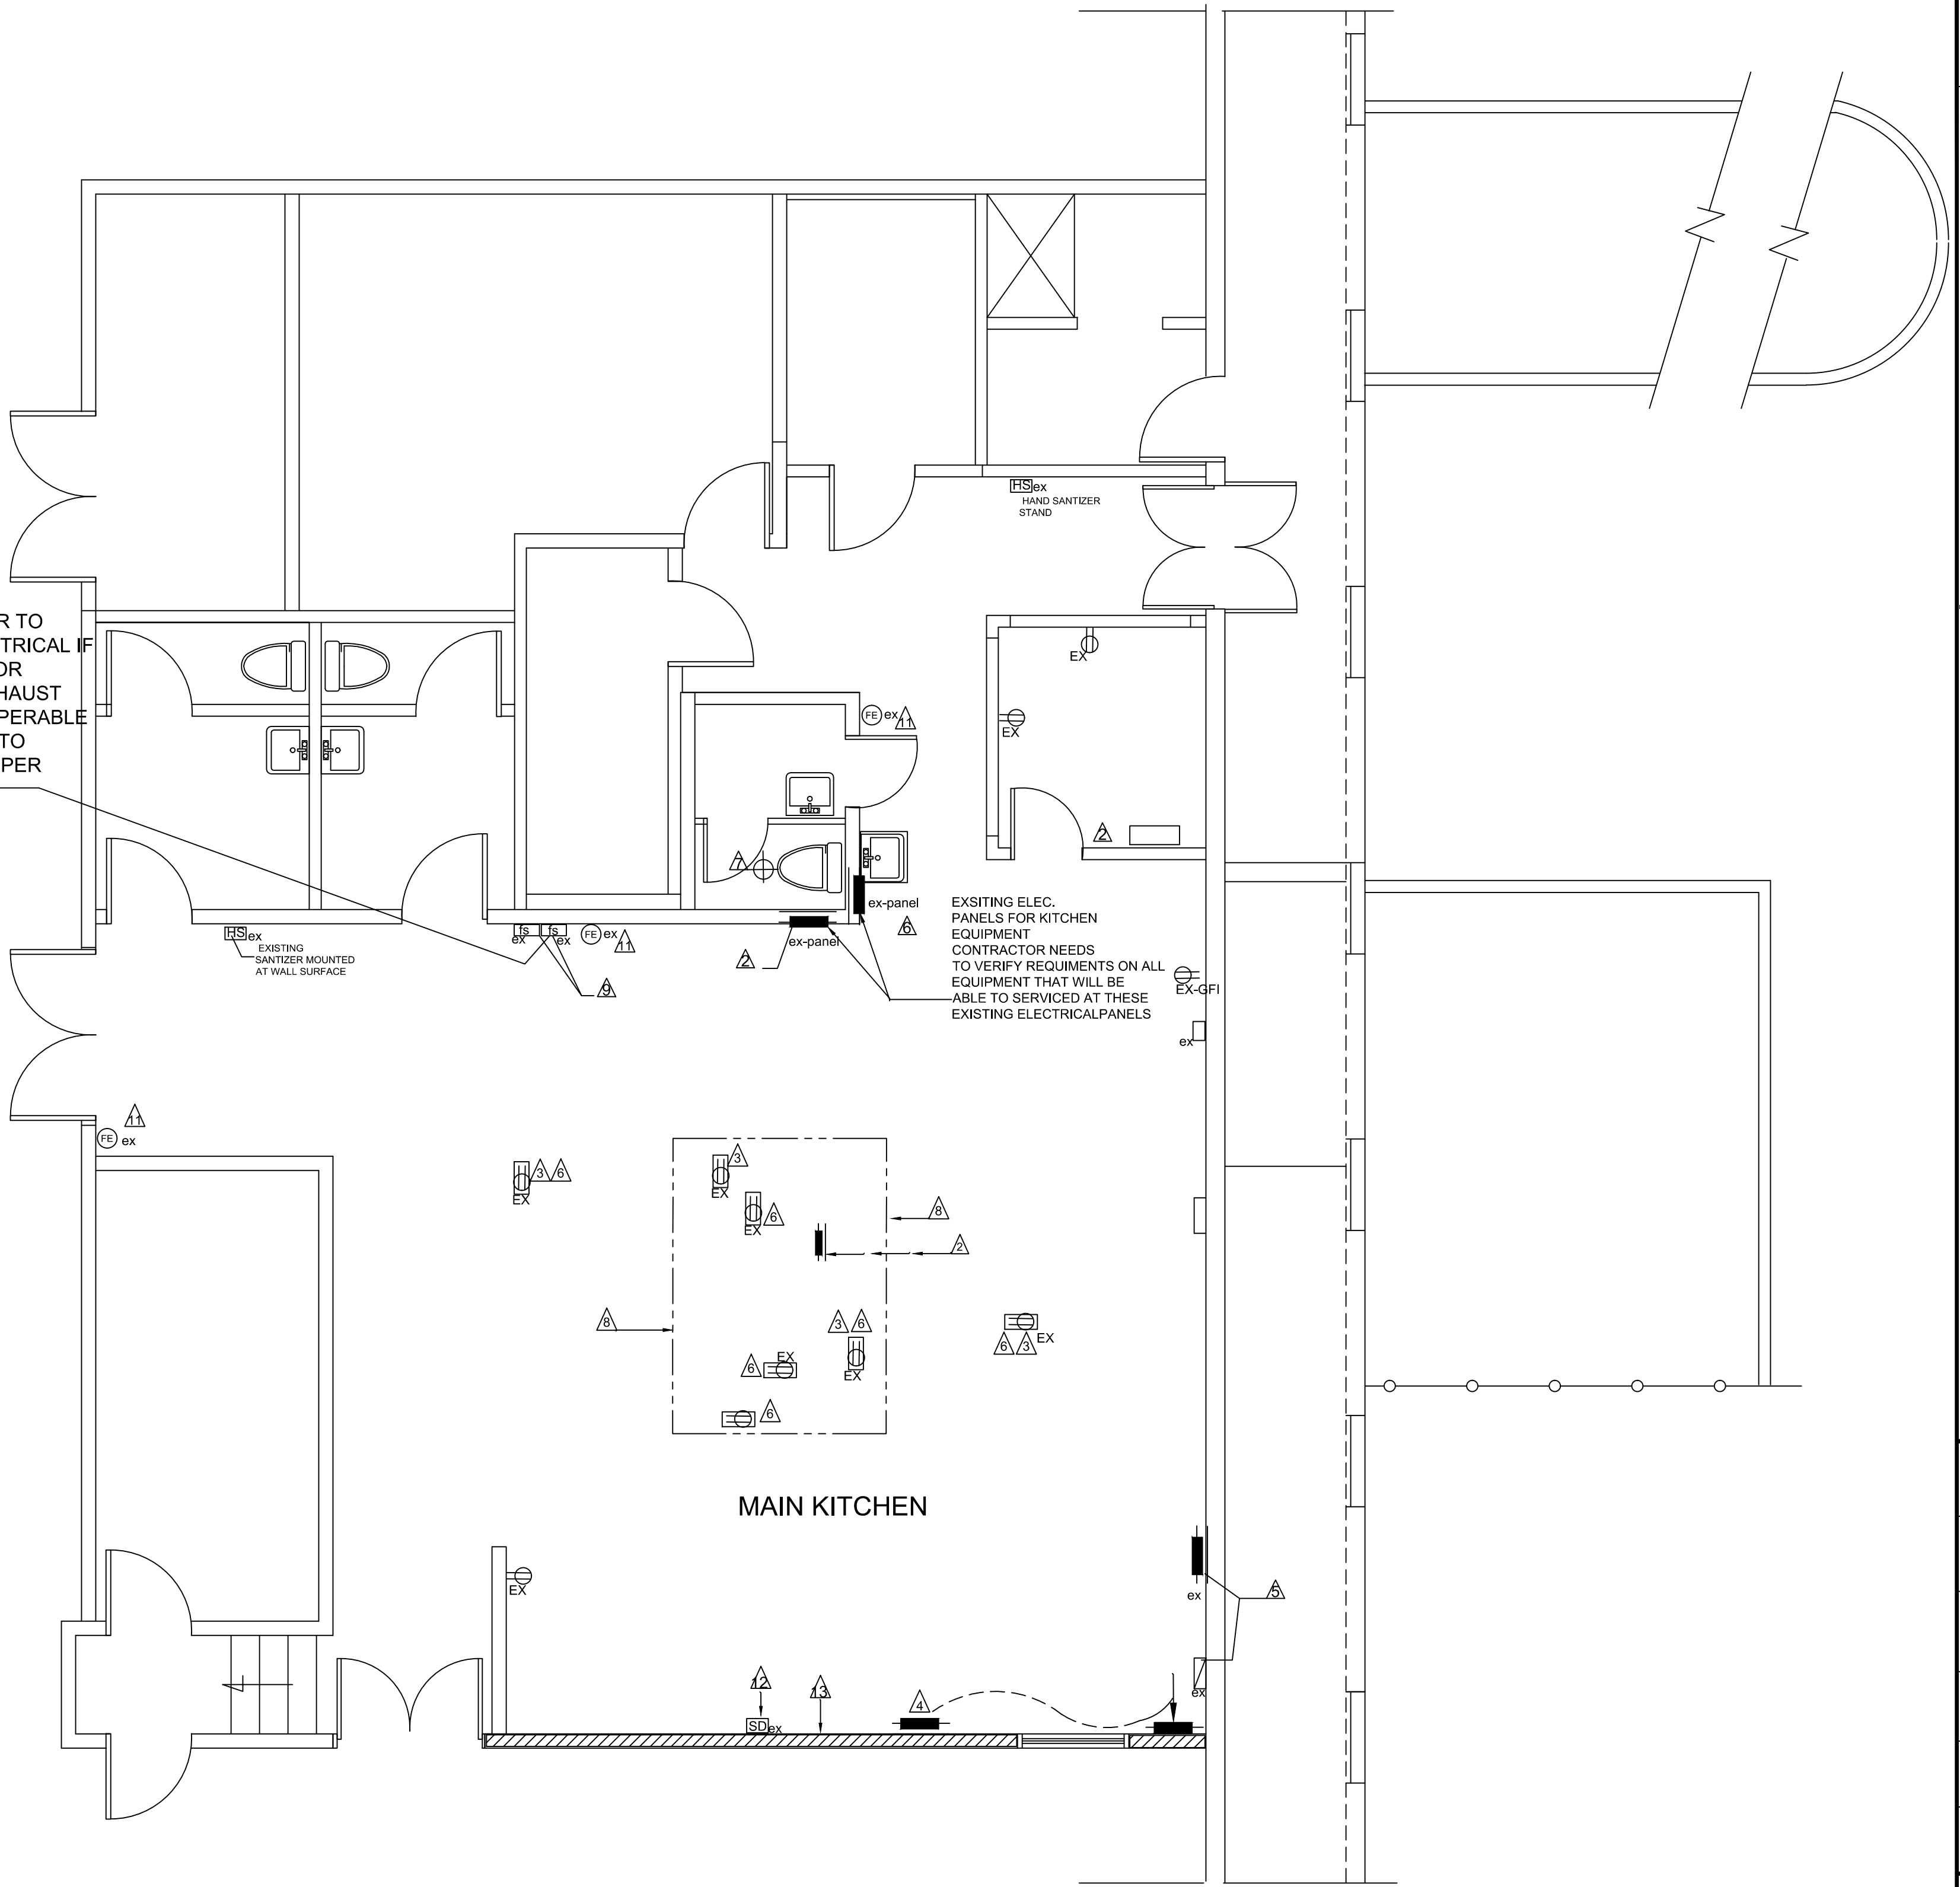

EXISTING ELECTRICAL LAYOUT & NOTES

SCALE 1/4" = 1'-0"

Caribbean Professional Consultants
212 BOURNEFIELD LINDBERG BAY, ST THOMAS
P.O. Box 30567
St Thomas U.S.V.I. 00803
Tel.: 340-774-3357

REVISIONS		REMARKS	
NO.	DATE		

EXISTING ELECTRICAL LAYOUT & NOTES
E. BENJAMIN OLIVER ELEMENTARY SCHOOL
148-325 PLAMETTO ROAD
ST THOMAS U.S. VIRGIN ISLANDS

DRAWN BY:	LD
CHECKED BY:	E. BLAIZE
APPROVED BY:	E. BLAIZE
CONTRACT NO.:	CONTRACT.NO.
PROJECT NO.:	PROJ.NO.
DATE:	



SHEET NO.:

EX-E1.2

SHEET NO. # OF # SHEETS